


Sonya and Brad Geuke Geuke Residence

POWDER HORN RANCH PUD PHASE THREE BLOCK M
LOT 3 SHERIDAN WY 82801

Powder Horn Final Design Review Submittal
08.05.26

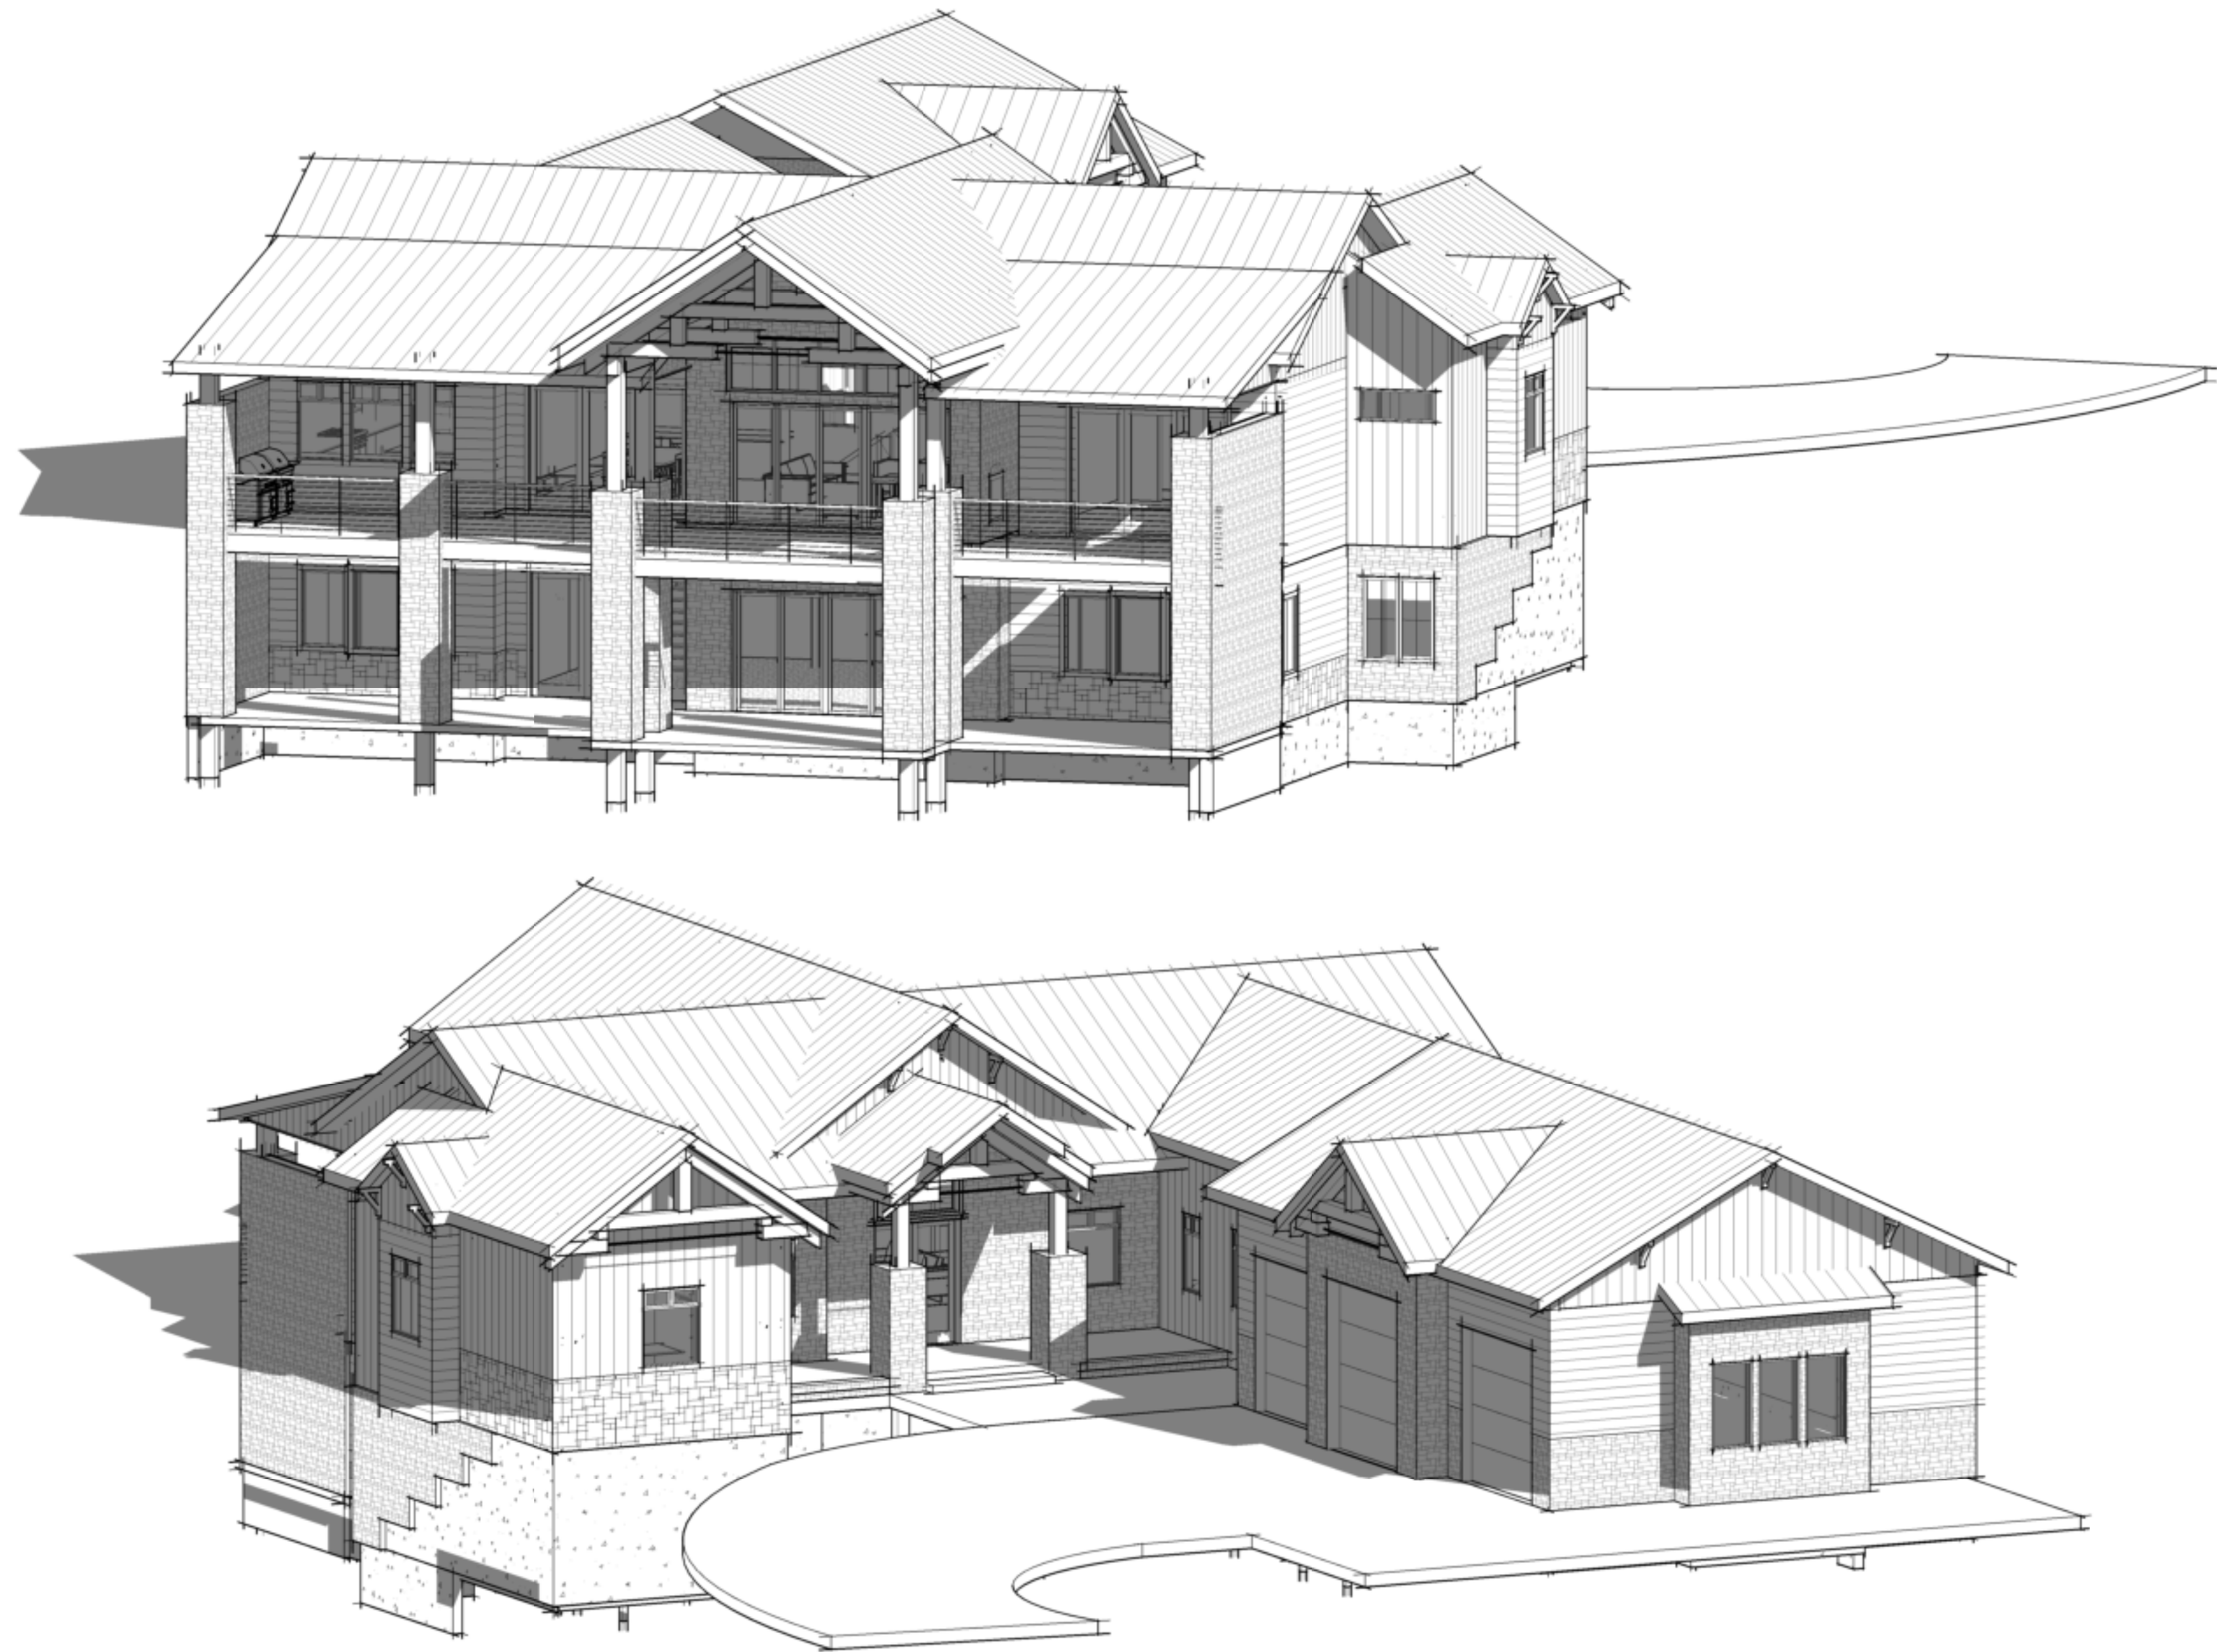

SHEET LIST

G-001	COVER SHEET
A-001	SITE PLAN
A-100	FOUNDATION LEVEL PLAN
A-101	LOWER LEVEL PLAN
A-102	FIRST LEVEL FLOOR PLAN
A-151	ROOF PLAN
A-201	EXTERIOR ELEVATIONS
A-202	EXTERIOR ELEVATIONS
A-301	BUILDING SECTIONS
A-701	FIRST LEVEL EXTERIOR LIGHTING FLOOR PLAN
A-901	3D VIEWS

DESIGN TEAM

ARCHITECT
STUDIO CMS ARCHITECTS LLC
CYDNEY MEANS
PO BOX 313
SHERIDAN, WY 82801
307.299.1001

PROJECT INFO

ADDRESS:
LEGAL DESCRIPTION:
POWDER HORN RANCH PUD PHASE THREE BLOCK M
LOT 3

 
LOT AREA:
TOTAL SQ FT = 22,068

PROPOSED STRUCTURE (SINGLE FAMILY RESIDENCE)

BUILDING CODE:
2024 INTERNATIONAL FIRE CODE
2024 INTERNATIONAL BUILDING CODE
2024 INTERNATIONAL RESIDENTIAL CODE
2024 INTERNATIONAL MECHANICAL CODE
2024 INTERNATIONAL PLUMBING CODE
2024 INTERNATIONAL FUEL GAS CODE
2024 INTERNATIONAL ENERGY CONSERVATION CODE

CONSTRUCTION TYPE: TYPE 5B - WOOD FRAMED

OCCUPANY GROUP: R-3 SINGLE FAMILY RESIDENCE



Studio CMS

PO BOX 313 | Sheridan, Wyoming 82801 | 307.299.1001
All reproduction & intellectual property rights reserved © 2026 Studio CMS LLC

Project Status:

Powder Horn Final Design
Review Submittal

Geuke Residence

POWDER HORN RANCH PUD PHASE THREE BLOCK M LOT 3 SHERIDAN WY

82801

Prepared for:

Sonya and Brad Geuke

Revisions:

No.	Description	Date

Project No: 72

Drawn By: CM Checked By: CLM


Sheet Title:

COVER SHEET

Sheet Number:


G-001

Original Drawing: 100% = 34" x 22" - DO NOT SCALE WHEN REPRODUCED AT ANY OTHER SIZE

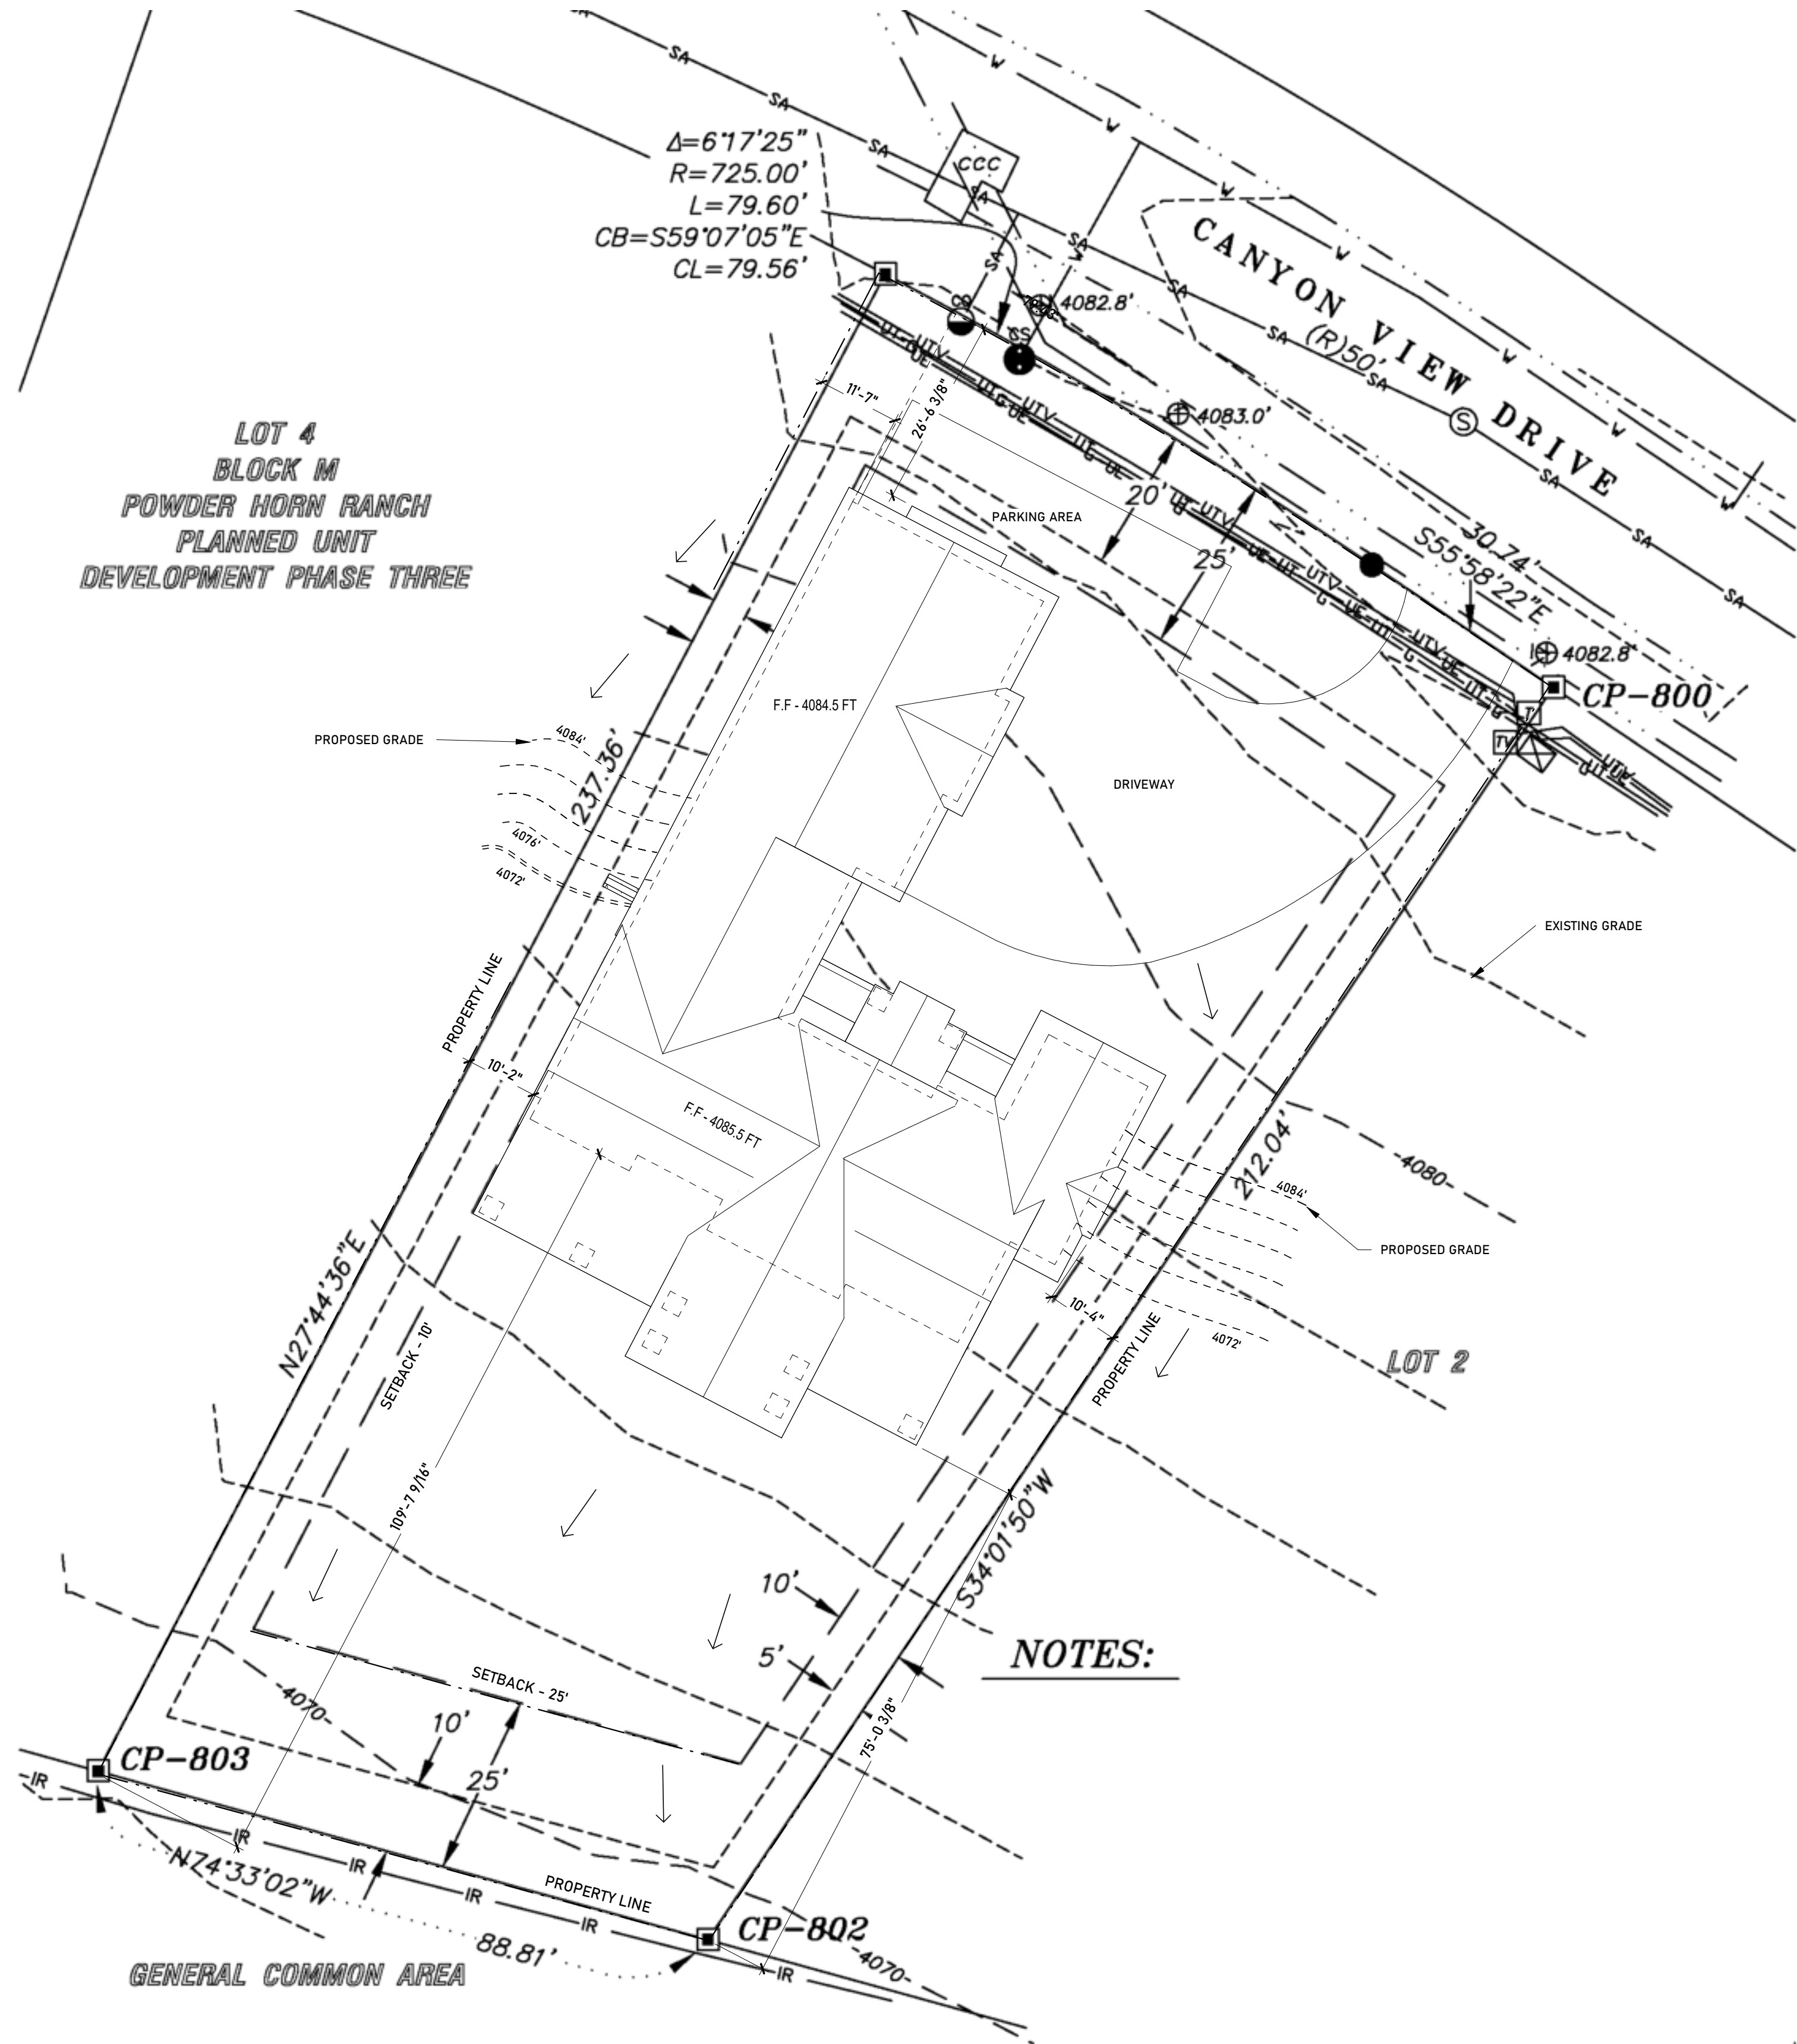

NOTES:

 Angle to True North = 27.00°



PROJECT NORTH



A1 Site Plan - Building Envelope Placement
Scale: 1/16" = 1'-0"



Studio CMS

PO BOX 313 | Sheridan, Wyoming 82801 | 307.299.1001
All reproduction & intellectual property rights reserved © 2026 Studio CMS LLC

Project Status:

Powder Horn Final Design
Review Submittal

Geuke Residence

POWDER HORN RANCH PUD PHASE THREE BLOCK M LOT 3 SHERIDAN WY
82801

Prepared for:
Sonya and Brad Geuke

Revisions:

No.	Description	Date

Project No: 72


Drawn By: LS Checked By: CLM

Sheet Title:

SITE PLAN

Sheet Number:

A-001

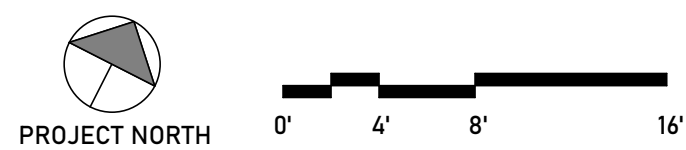

Area Schedule - Gross Footprint	
Name	Area
Lower Level	
Area	2472 SF
	2472 SF
First Level	
FIRST LEVEL	2756 SF
GARAGE	1551 SF
	4307 SF
Total Gross Footprint:	6779 SF



Project Status:

Powder Horn Final Design Review Submittal

Geuke Residence

POWDER HORN RANCH PUD PHASE THREE BLOCK M LOT 3 SHERIDAN WY
82801

Prepared for:

Sonya and Brad Geuke

[illegible]

Project No: 72

Drawn By: CM Checked By: CLM


FOUNDATION LEVEL PLAN

Sheet Number

A-100

Original Drawing: 100% = 34" x 22" - DO NOT SCALE WHEN REPRODUCED AT ANY OTHER SIZE

A1 LOWER LEVEL PLAN
Scale: 1/8" = 1'-0"

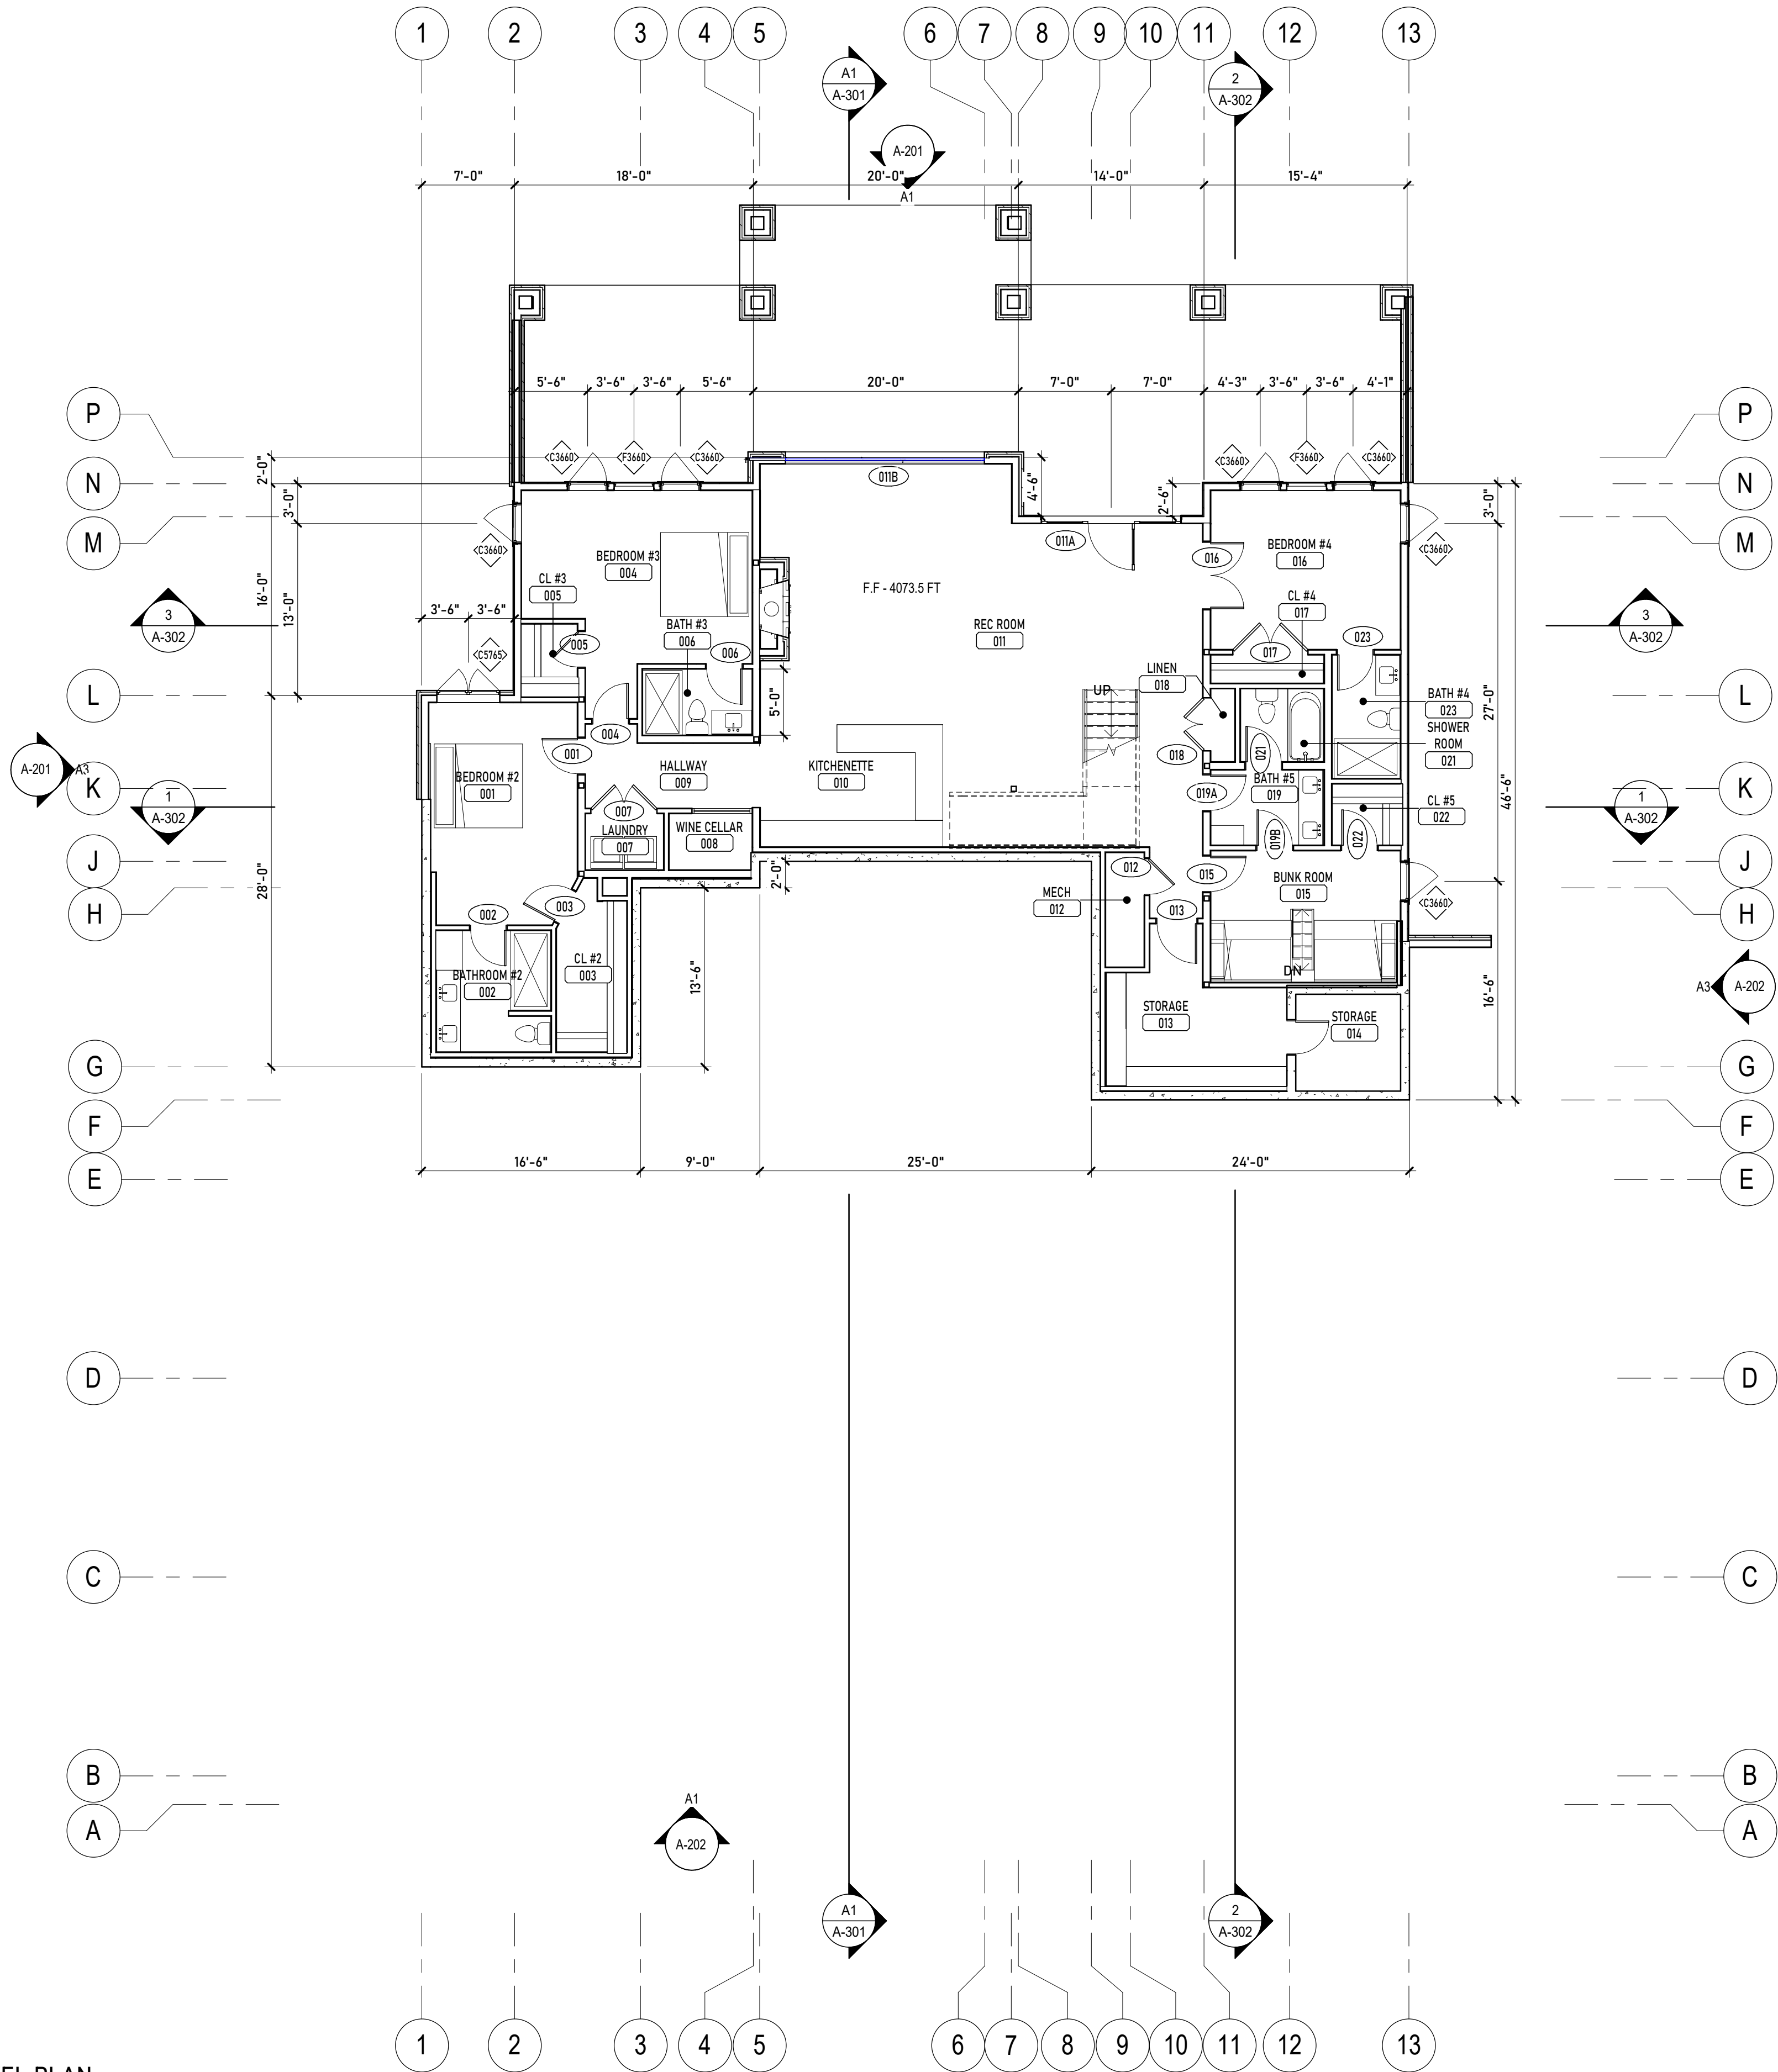

Room Schedule -Basement Level		
Number	Name	Area
001	BEDROOM #2	181 SF
002	BATHROOM #2	78 SF
003	CL #2	62 SF
004	BEDROOM #3	227 SF
005	CL #3	23 SF
006	BATH #3	41 SF
007	LAUNDRY	25 SF
008	WINE CELLAR	28 SF
009	HALLWAY	70 SF
010	KITCHENETTE	129 SF
011	REC ROOM	777 SF
012	MECH	25 SF
013	STORAGE	125 SF
014	STORAGE	58 SF
015	BUNK ROOM	141 SF
016	BEDROOM #4	172 SF
017	CL #4	18 SF
018	LINEN	10 SF
019	BATH #5	49 SF
021	SHOWER ROOM	35 SF
022	CL #5	24 SF
023	BATH #4	48 SF
Total Net Floor Area:		2347 SF

Area Schedule - Gross Footprint	
Name	Area
Lower Level	
Area	2472 SF
First Level	
FIRST LEVEL	2756 SF
GARAGE	1551 SF
Total Gross Footprint:	6779 SF



Studio CMS

PO BOX 313 | Sheridan, Wyoming 82801 | 307.299.1001
All reproduction & intellectual property rights reserved © 2026 Studio CMS LLC

Project Status:

**Powder Horn Final Design
Review Submittal**

Geuke Residence

POWDER HORN RANCH PUD PHASE THREE BLOCK M LOT 3 SHERIDAN WY
82801

Prepared for:
Sonya and Brad Geuke

Revisions:

No.	Description	Date

Project No: 72

Drawn By: CM Checked By: CLM

Sheet Title:


LOWER LEVEL PLAN

Sheet Number:

A-101

Original Drawing: 100% = 34" x 22" - DO NOT SCALE WHEN REPRODUCED AT ANY OTHER SIZE

A1 First Level Floor Plan
Scale: 1/8" = 1'-0"

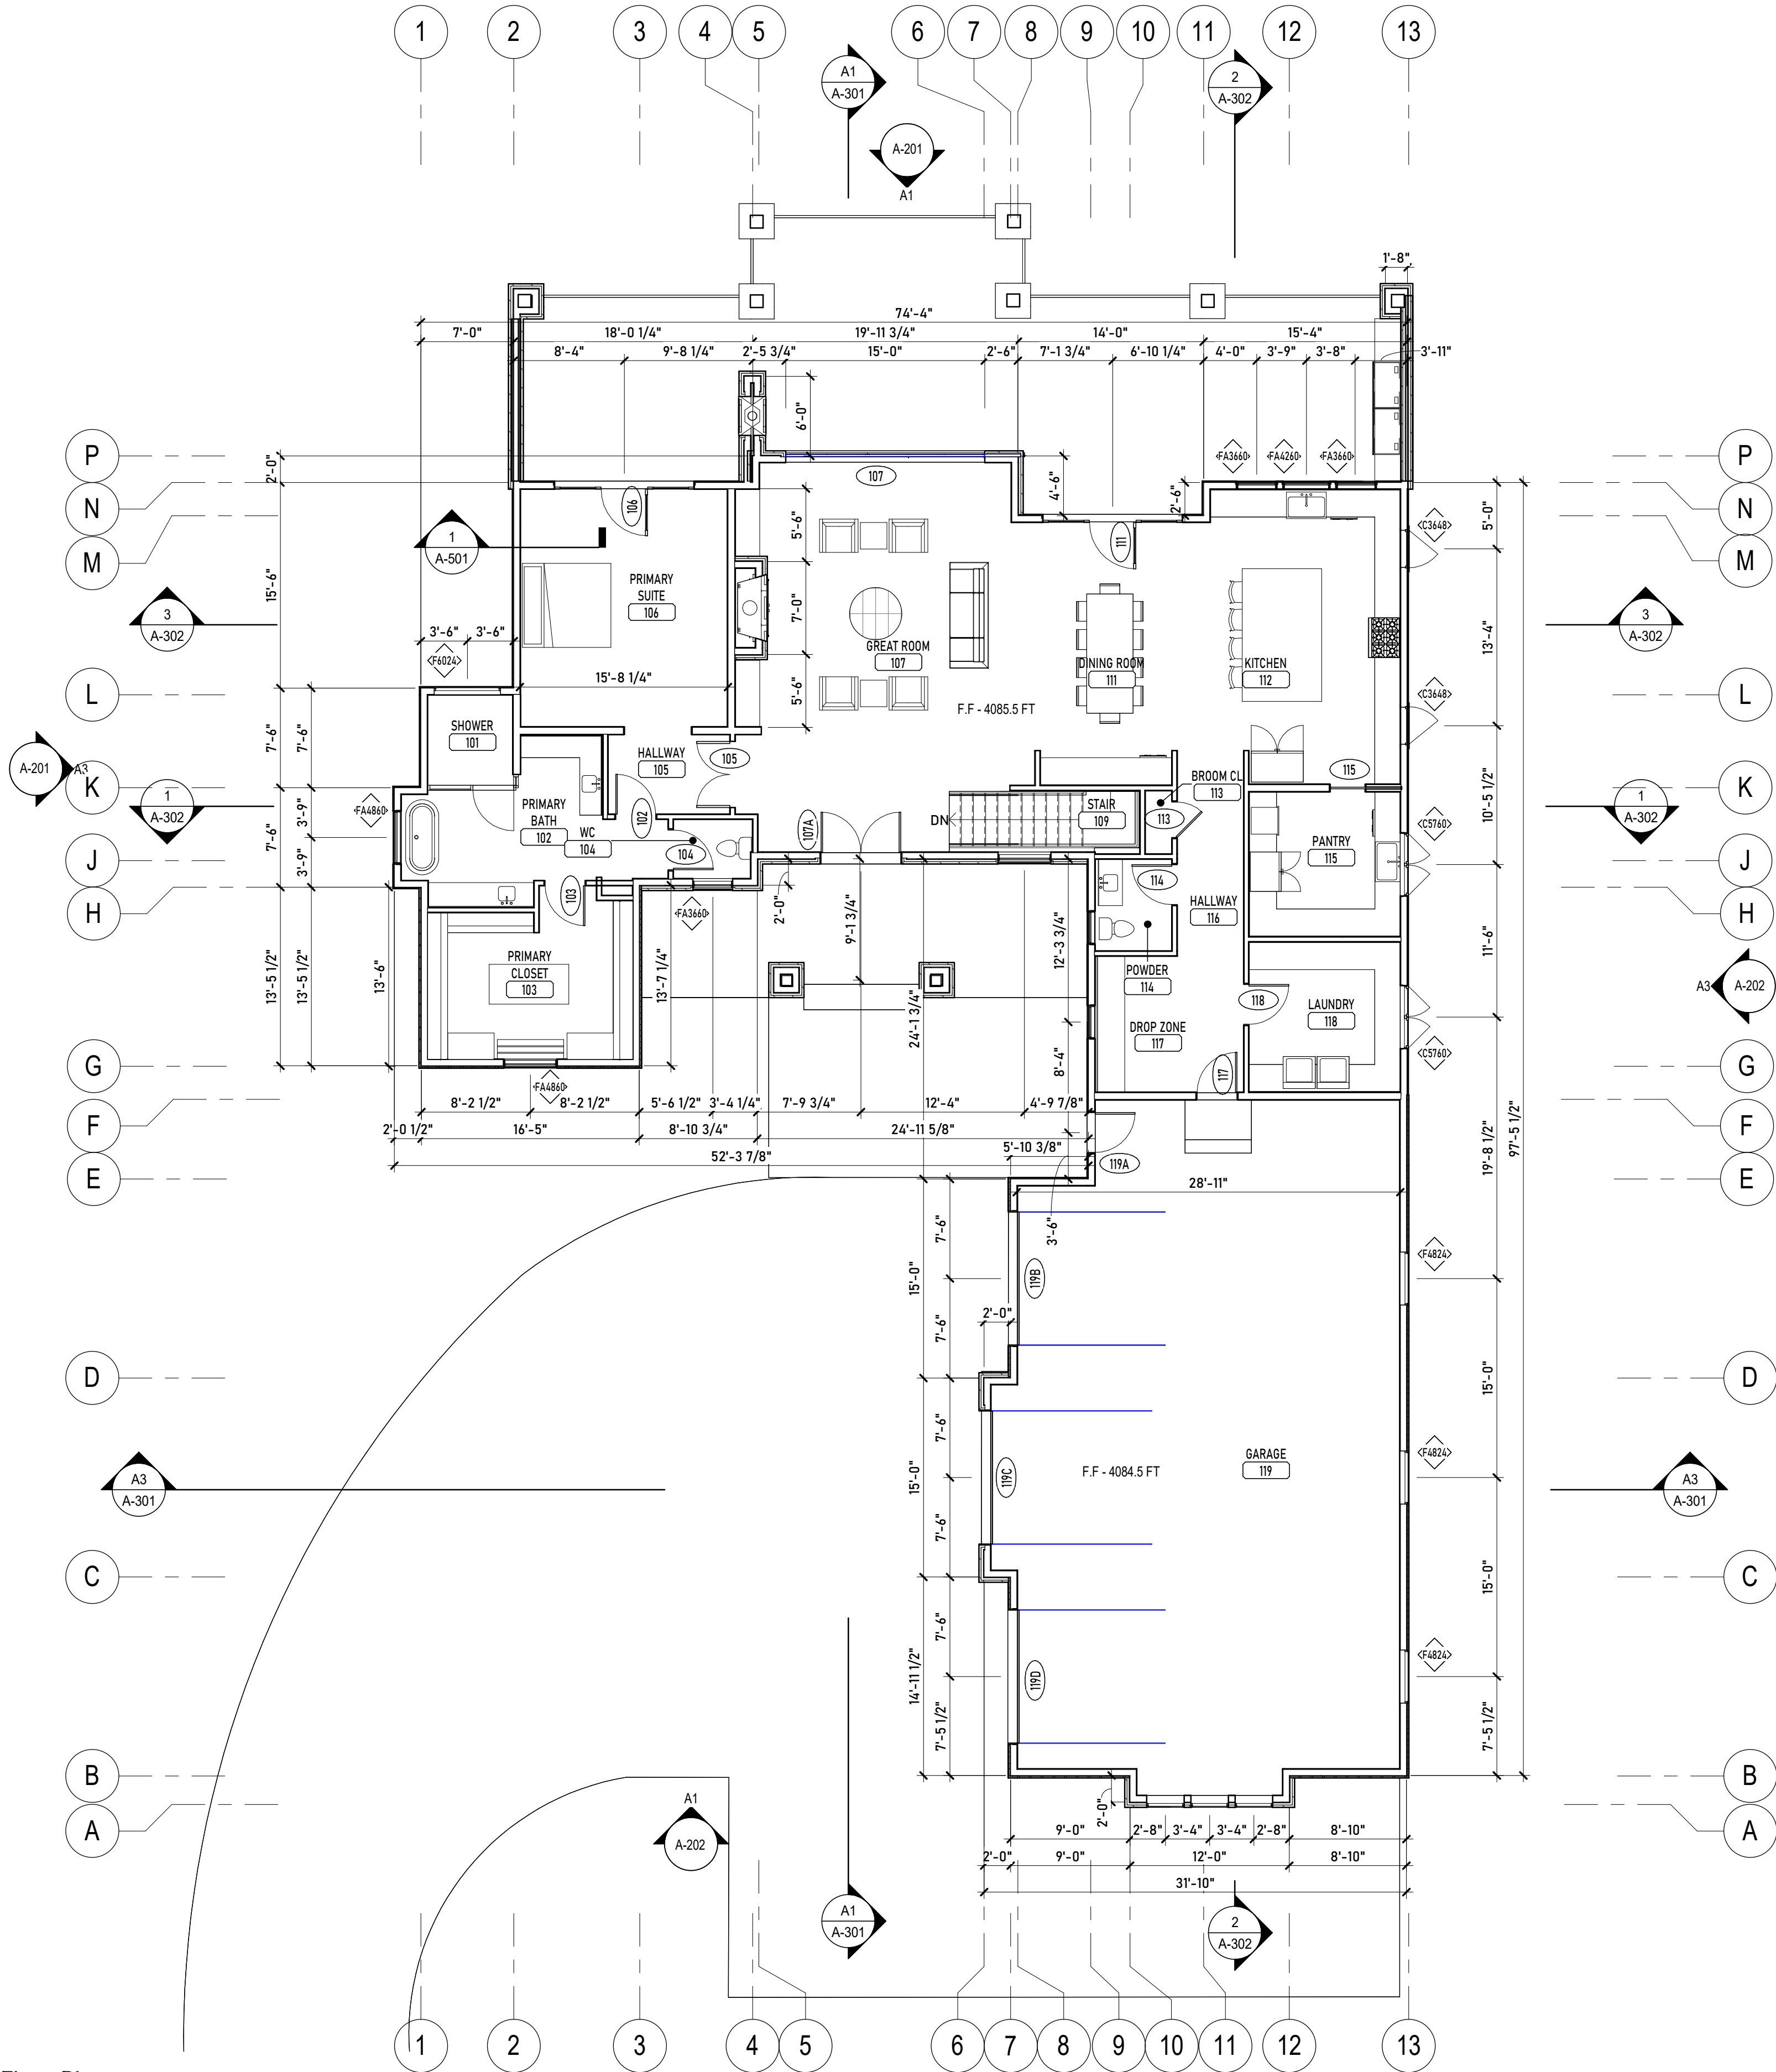

Area Schedule - Gross Footprint

Name	Area
Lower Level	
Area	2472 SF
First Level	
FIRST LEVEL	2756 SF
GARAGE	1551 SF
	4307 SF
Total Gross Footprint:	6779 SF

Room Schedule - Level 1

Number	Name	Area
101	SHOWER	45 SF
102	PRIMARY BATH	141 SF
103	PRIMARY CLOSET	177 SF
104	WC	26 SF
105	HALLWAY	55 SF
106	PRIMARY SUITE	279 SF
107	GREAT ROOM	561 SF
109	STAIR	66 SF
111	DINING ROOM	243 SF
112	KITCHEN	371 SF
113	BROOM CL	10 SF
114	POWDER	40 SF
115	PANTRY	124 SF
116	HALLWAY	61 SF
117	DROP ZONE	117 SF
118	LAUNDRY	129 SF
119	GARAGE	1464 SF
Total Net Floor Area:		3908 SF



Studio CMS

PO BOX 313 | Sheridan, Wyoming 82801 | 307.299.1001
All reproduction & intellectual property rights reserved © 2024 Studio CMS LLC

Project Status:

**Powder Horn Final Design
Review Submittal**

Geuke Residence

**POWDER HORN RANCH PUD PHASE THREE BLOCK M LOT 3 SHERIDAN WY
82801**

Prepared for:
Sonya and Brad Geuke

Revisions:

No.	Description	Date

Project No: 72

Drawn By: CM Checked By: CLM

Sheet Title:

**FIRST LEVEL FLOOR
PLAN**

Sheet Number:

A-102



Project Status:

Powder Horn Final Design Review Submittal

Geuke Residence

POWDER HORN RANCH PUD PHASE THREE BLOCK M LOT 3 SHERIDAN WY
82801

32801

Prepared for:

Sonya and Brad Geuke

Revisions

[illegible]

Project No: 72

Drawn By: CLM Checked By: CLM


Sheet Title

ROOF PLAN

Sheet Number:

A-151

Original Drawing: 100% = 34" x 22" - DO NOT SCALE WHEN REPRODUCED AT ANY OTHER SIZE

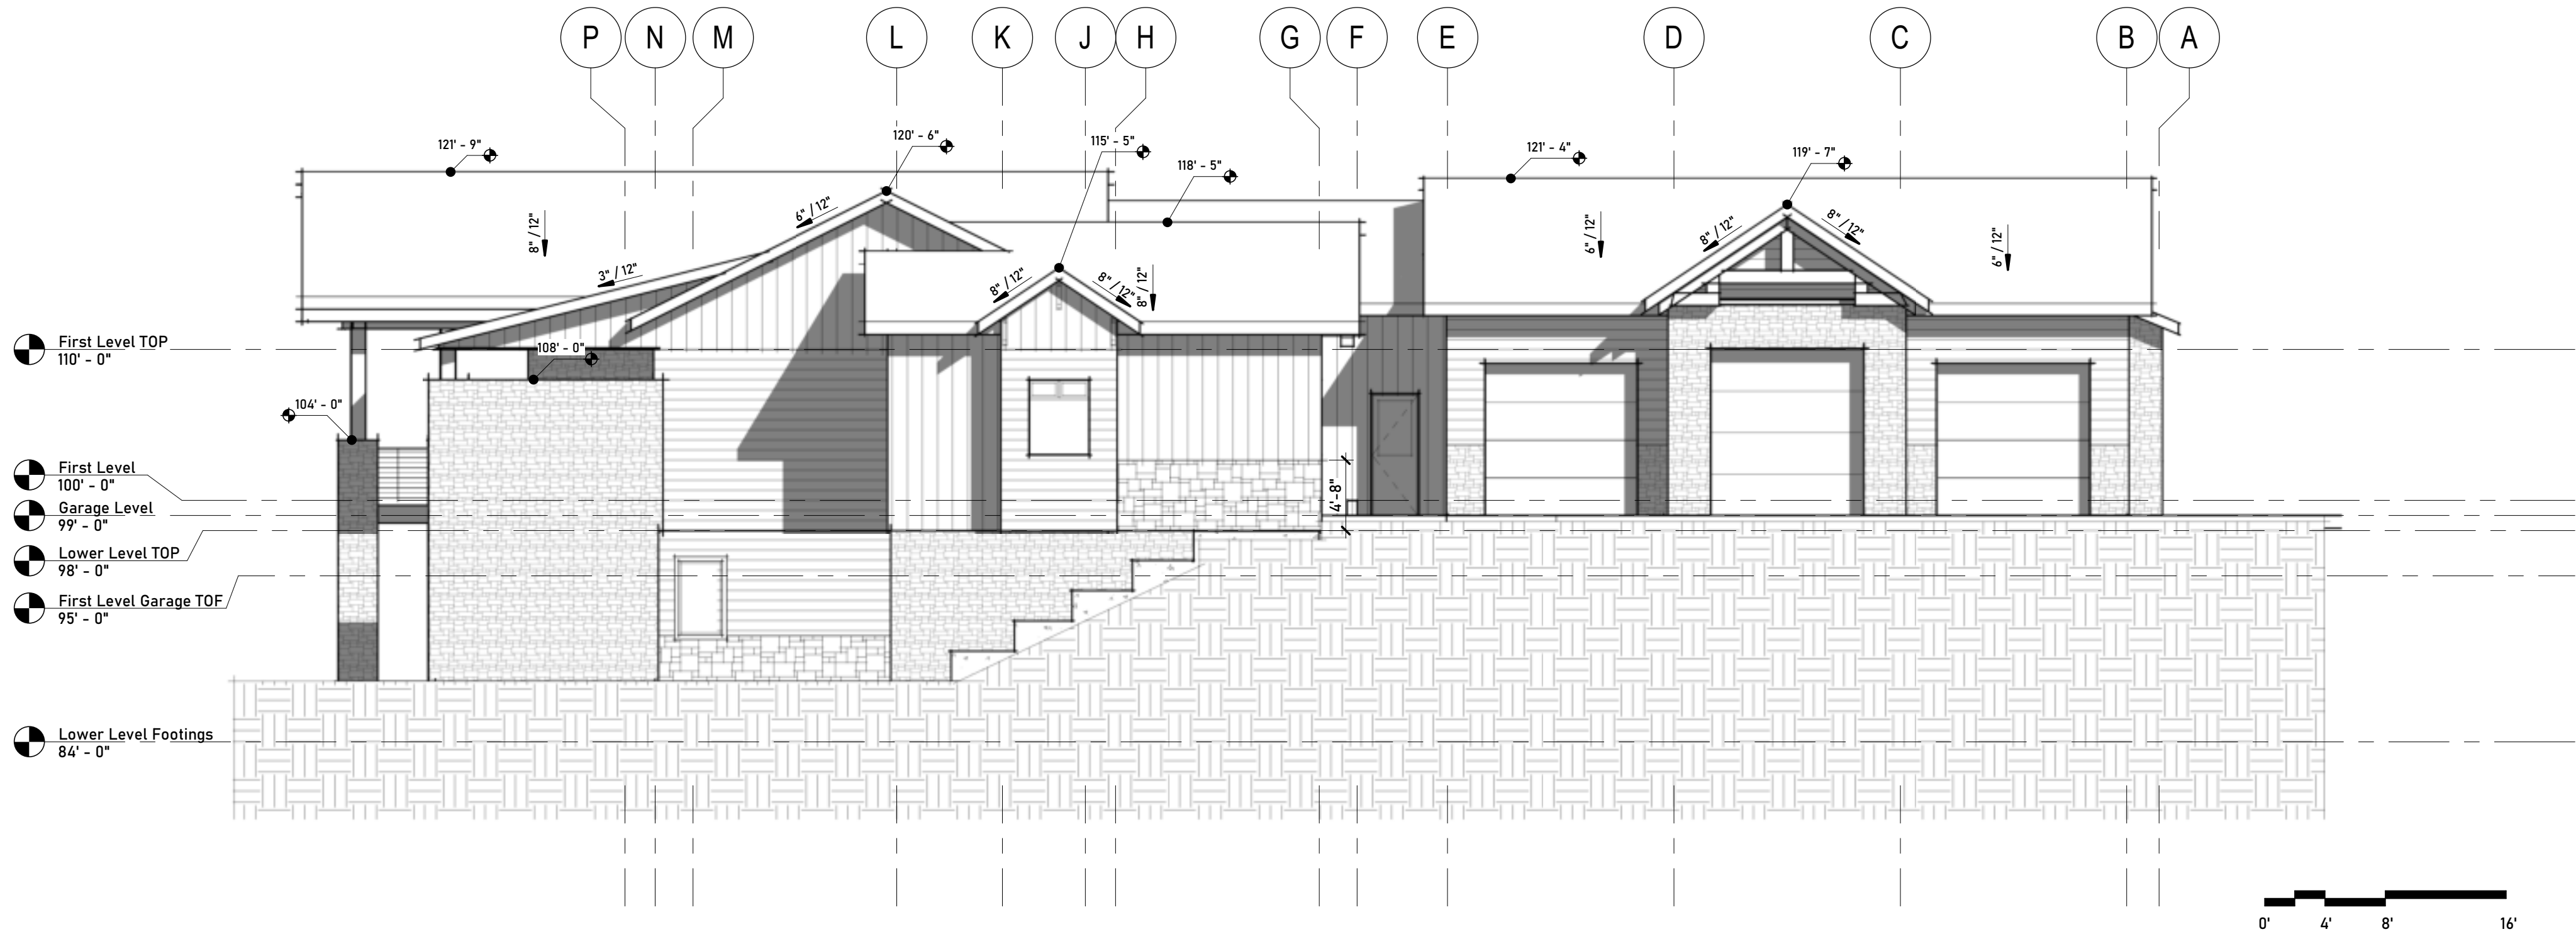

A3 Side Exterior Elevation 2
Scale: 1/8" = 1'-0"



A1 Back Exterior Elevation.
Scale: 1/8" = 1'-0"

Exterior Elevation Legend

- STONE CLAD SIDING
- HORIZONTAL SHIP LAP SIDING
- BOARD AND BATTEN SIDING



Studio CMS

PO BOX 313 | Sheridan, Wyoming 82801 | 307.299.1001
All reproduction & intellectual property rights reserved © 2026 Studio CMS LLC

Project Status:

**Powder Horn Final Design
Review Submittal**

Geuke Residence

POWDER HORN RANCH PUD PHASE THREE BLOCK M LOT 3 SHERIDAN WY
82801

Prepared for:
Sonya and Brad Geuke

Revisions:

No.	Description	Date

Project No: 72

Drawn By: CLM Checked By: CLM


Sheet Title:

EXTERIOR ELEVATIONS

Sheet Number:

A-201

Original Drawing: 100% = 34" x 22" - DO NOT SCALE WHEN REPRODUCED AT ANY OTHER SIZE

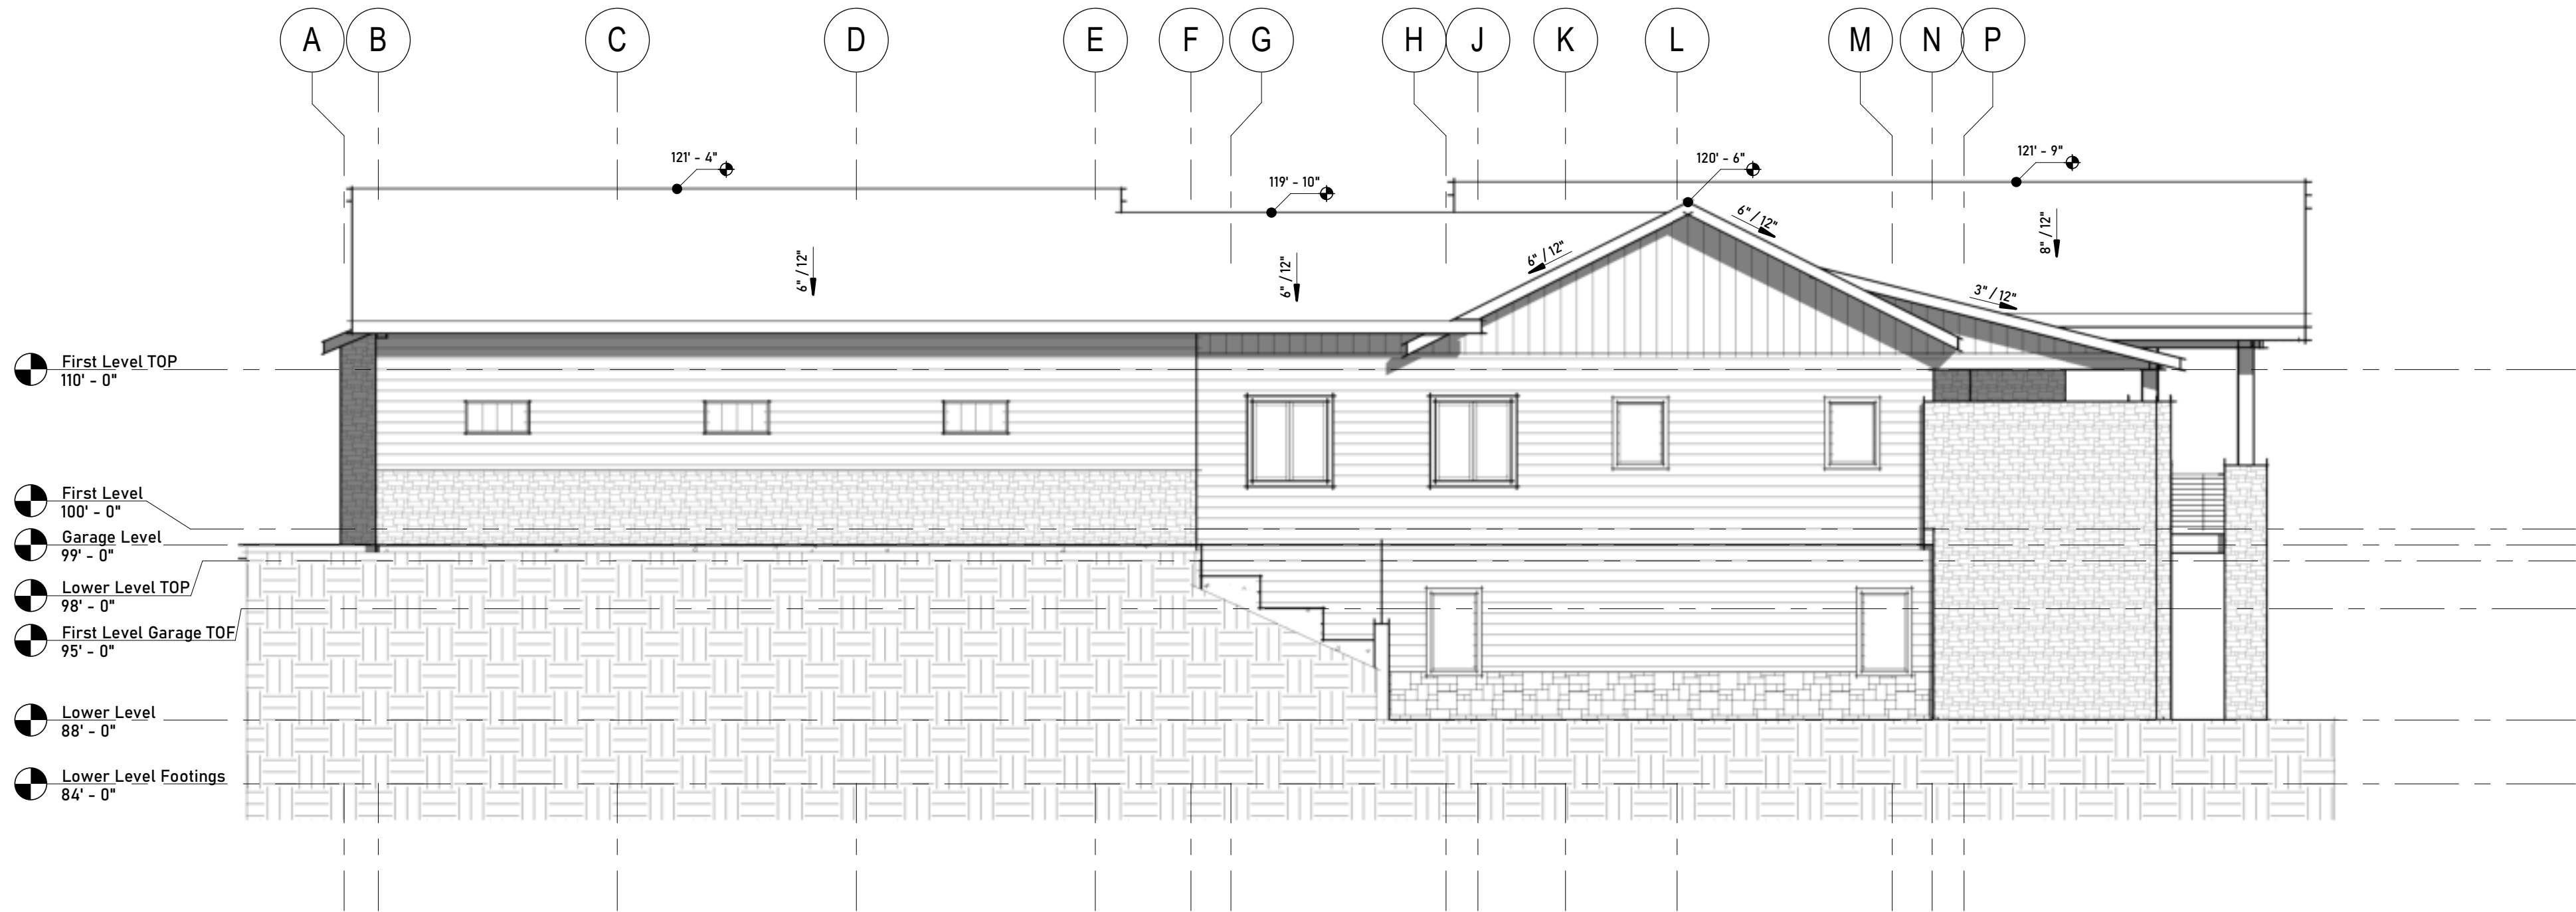

A3 Side Exterior Elevation 1
Scale: 1/8" = 1'-0"



Exterior Elevation Legend

- STONE CLAD SIDING
- HORIZONTAL SHIP LAP SIDING
- BOARD AND BATTEN SIDING



Studio CMS

PO BOX 313 | Sheridan, Wyoming 82801 | 307.299.1001
All reproduction & intellectual property rights reserved © 2024 Studio CMS LLC

Project Status:

**Powder Horn Final Design
Review Submittal**

Geuke Residence

POWDER HORN RANCH PUD PHASE THREE BLOCK M LOT 3 SHERIDAN WY

82801

Prepared for:

Sonya and Brad Geuke

Revisions:

No.	Description	Date

Project No: 72


Drawn By: CM Checked By: CLM

Sheet Title:

EXTERIOR ELEVATIONS

Sheet Number:


A-202

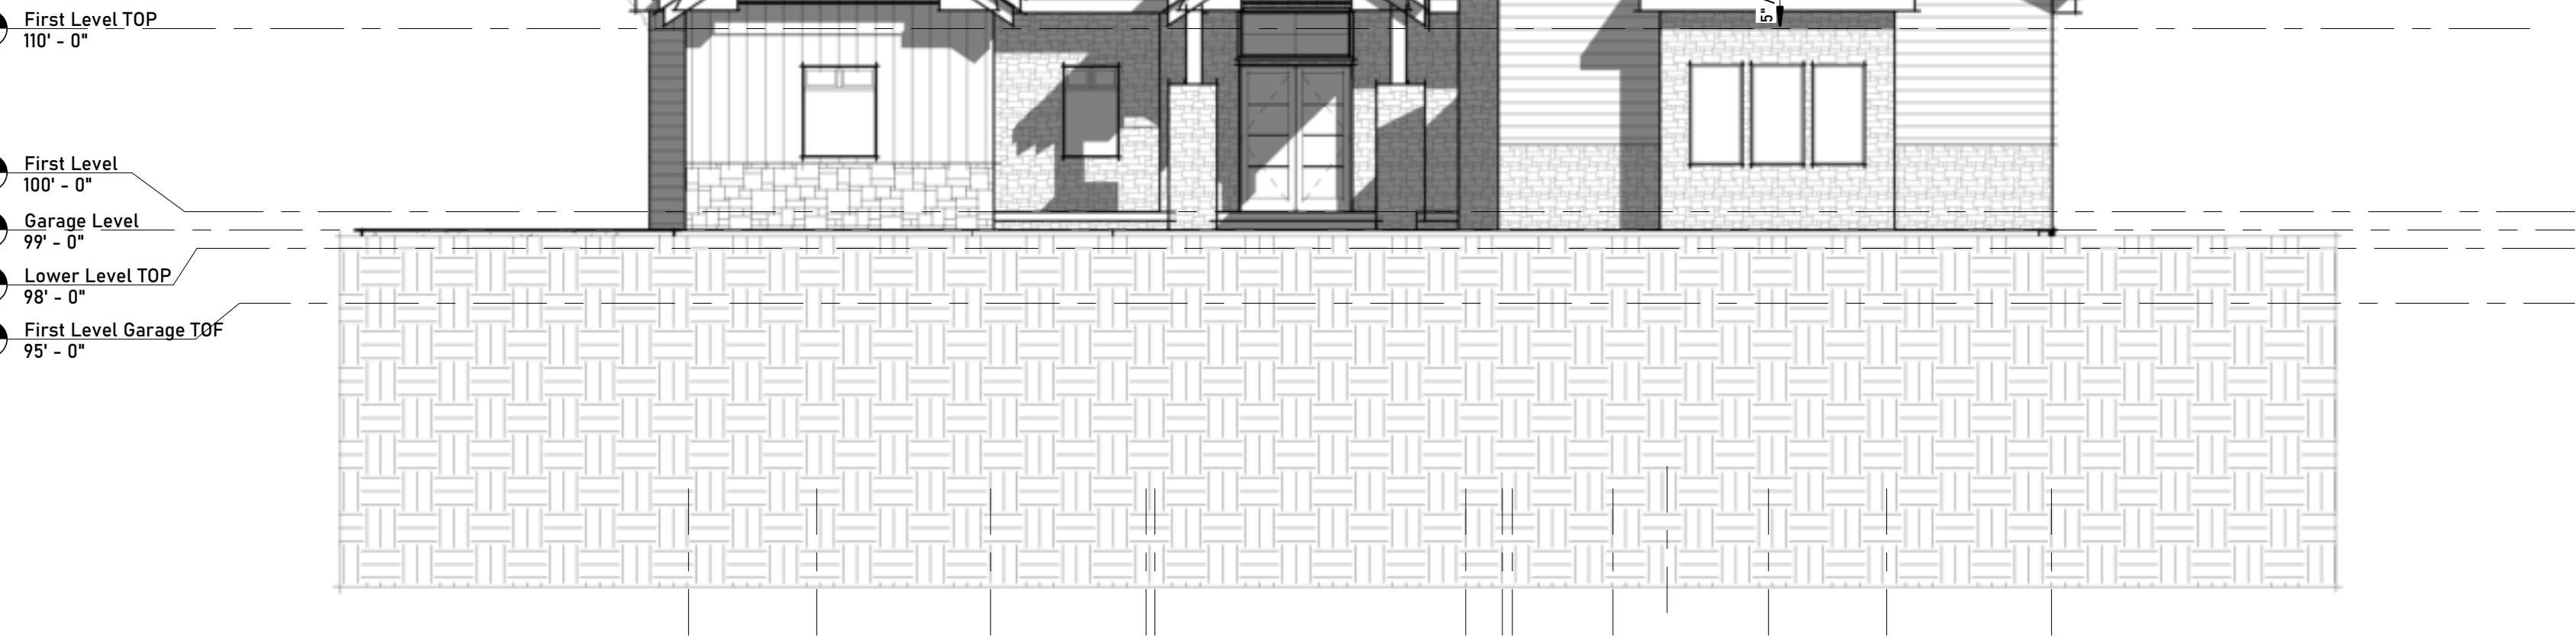


A1 Front Exterior Elevation
Scale: 1/8" = 1'-0"




Original Drawing: 100% = 34" x 22" - DO NOT SCALE WHEN REPRODUCED AT ANY OTHER SIZE

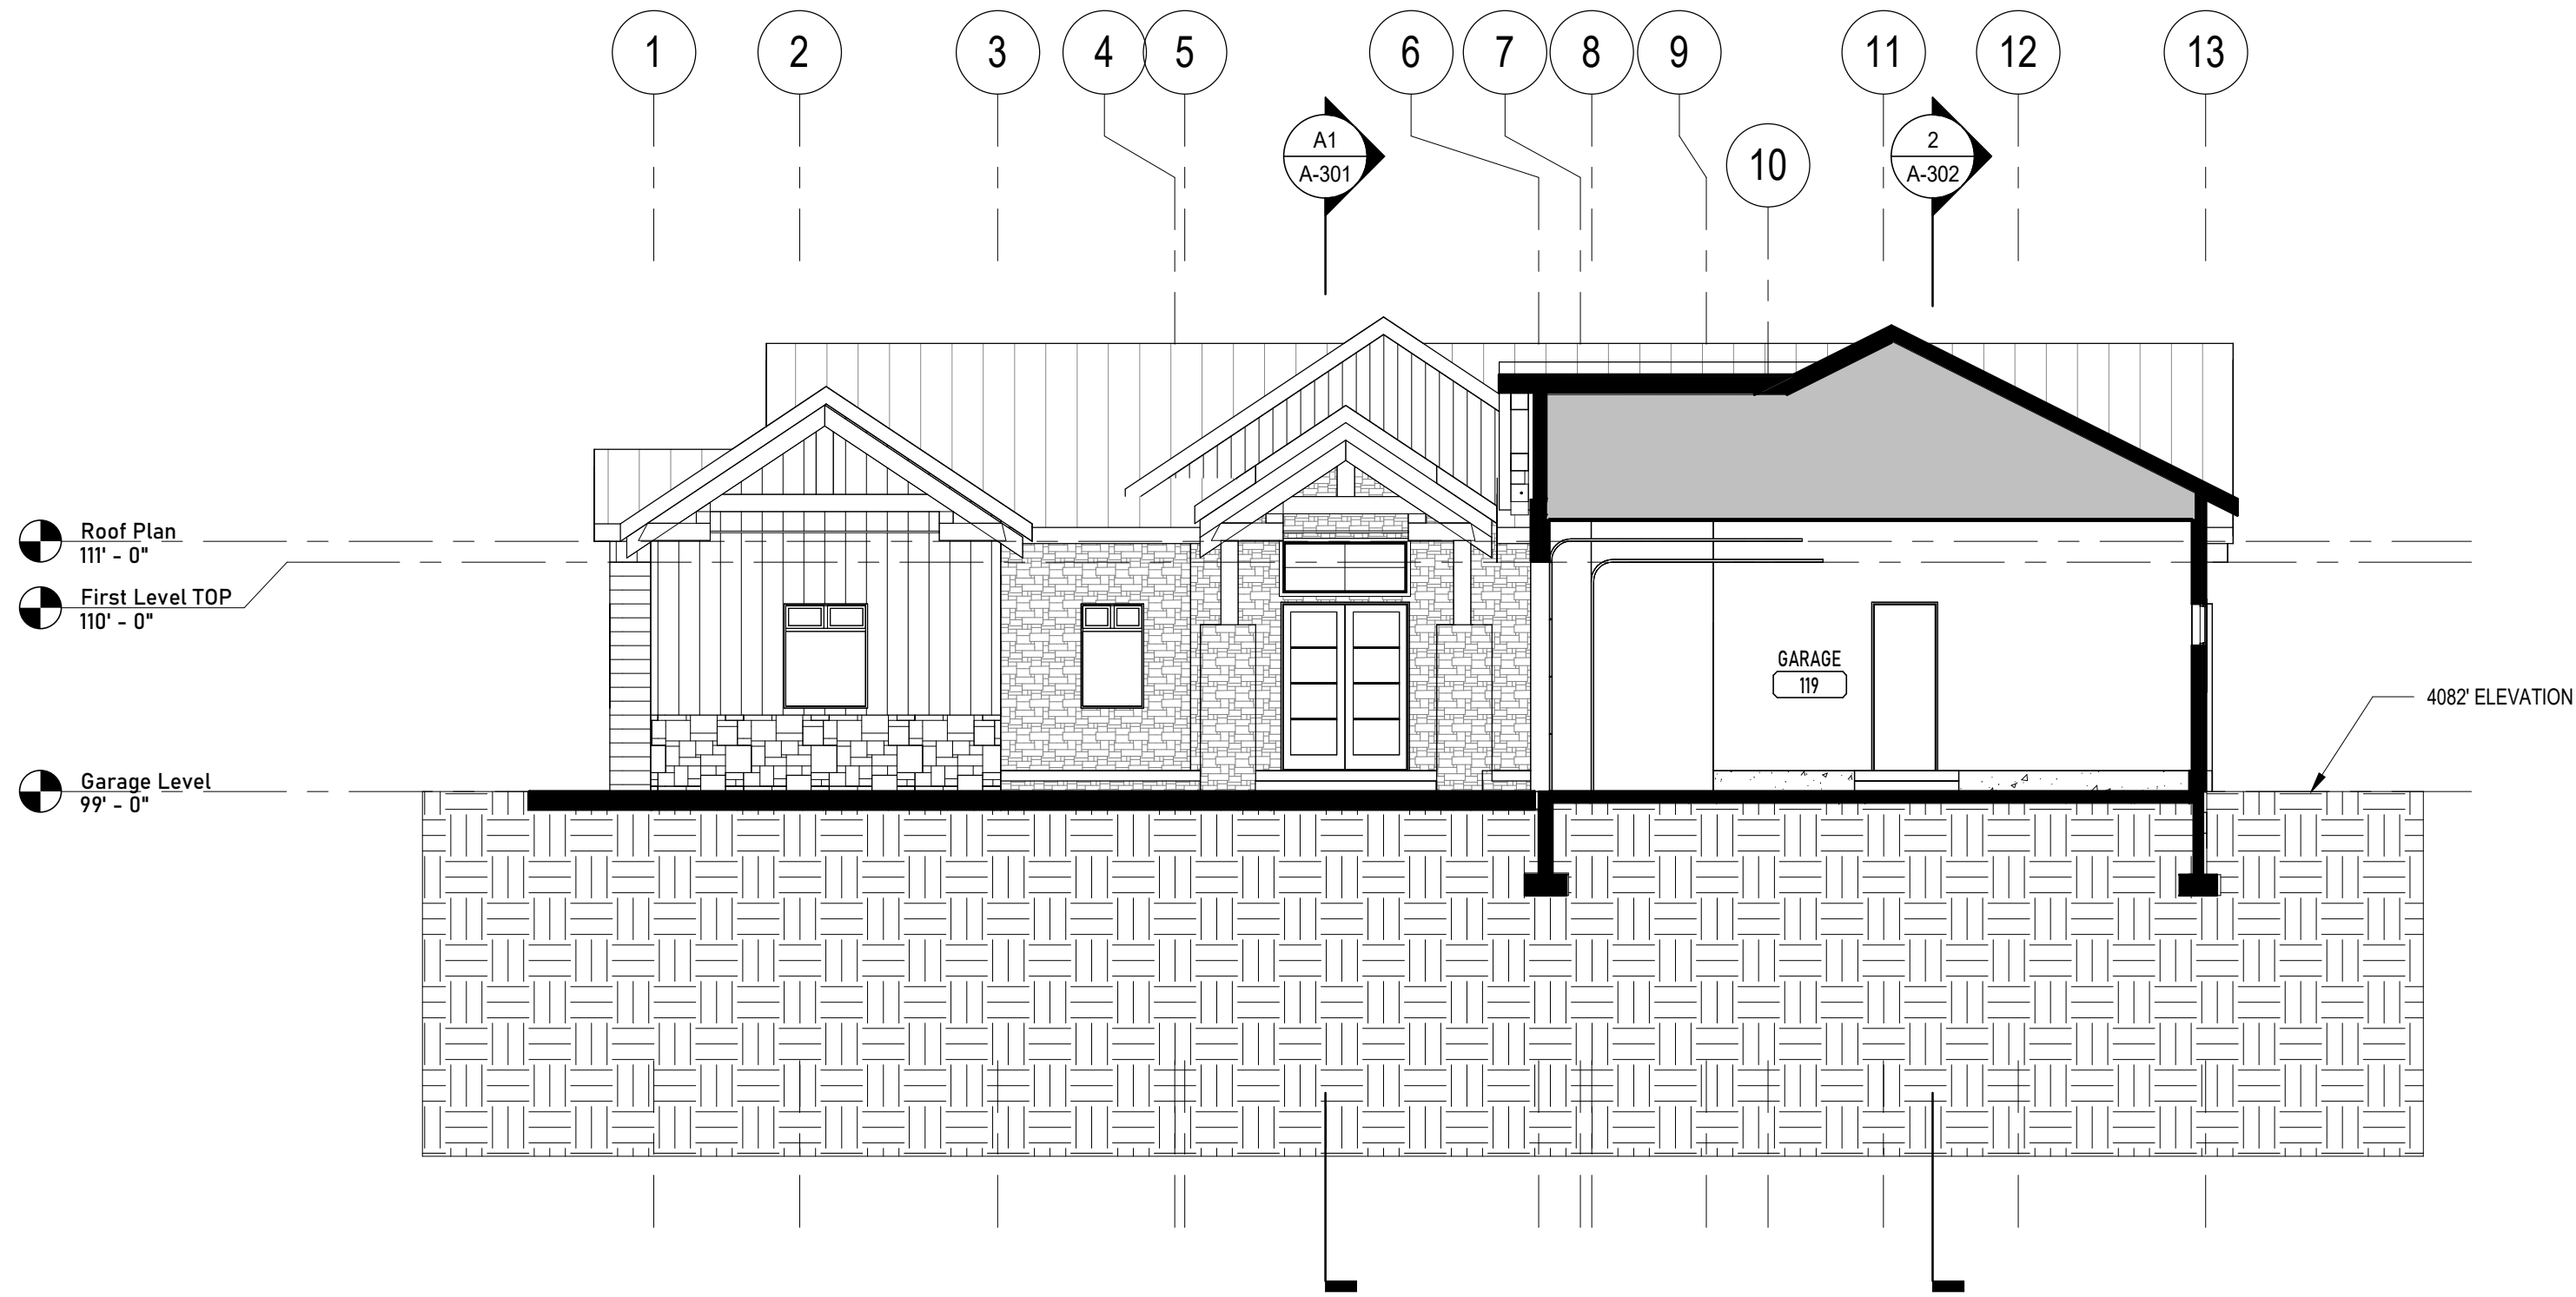

A3 Section 2
Scale: 1/8" = 1'-0"

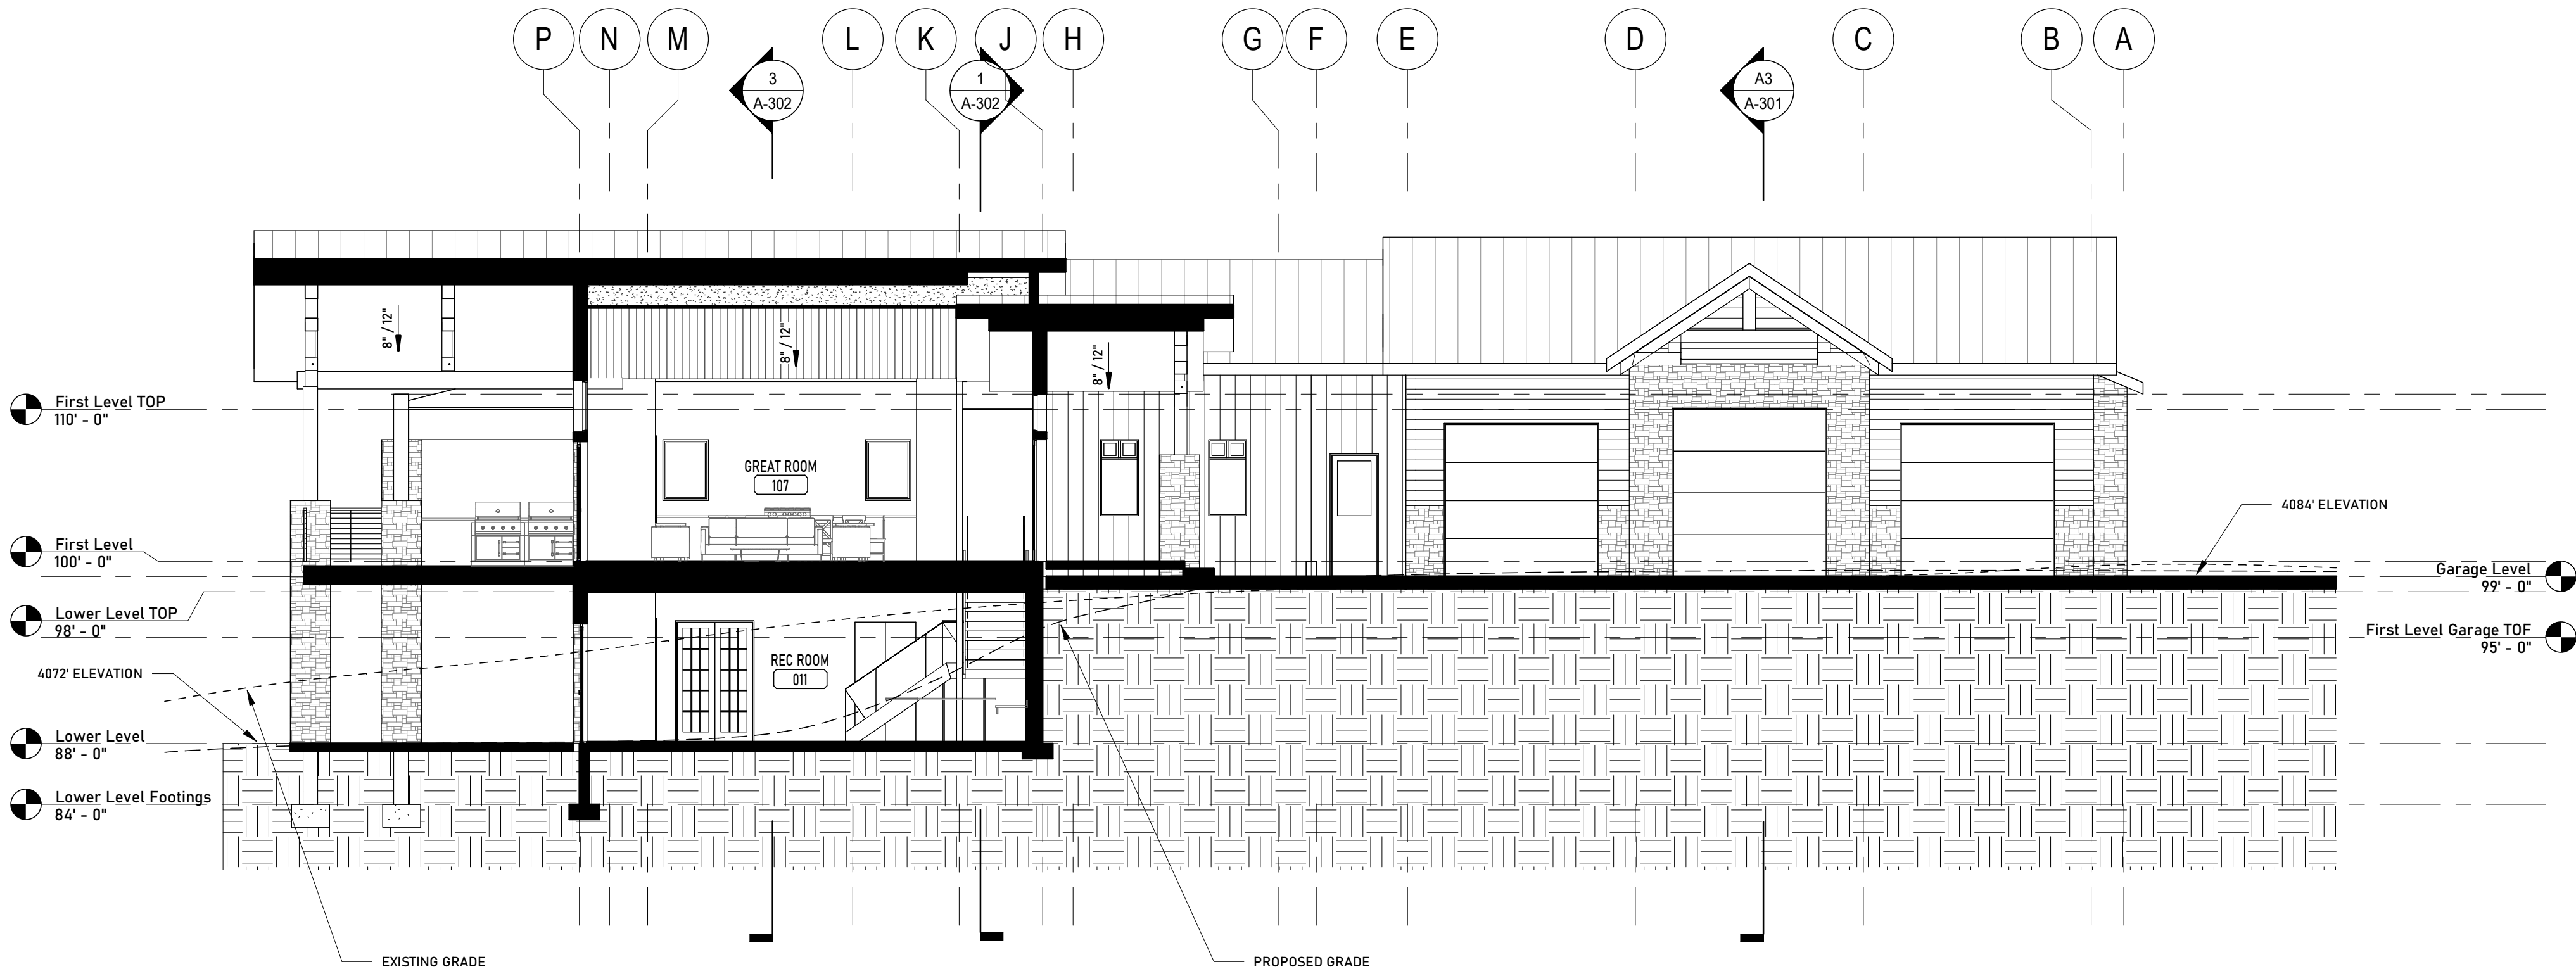

A1 Section 1
Scale: 1/8" = 1'-0"

 

Studio CMS

PO BOX 313 | Sheridan, Wyoming 82801 | 307.299.1001
All reproduction & intellectual property rights reserved © 2026 Studio CMS LLC

Project Status:

**Powder Horn Final Design
Review Submittal**

Geuke Residence

POWDER HORN RANCH PUD PHASE THREE BLOCK M LOT 3 SHERIDAN WY
82801

Prepared for:
Sonya and Brad Geuke

Revisions:

No.	Description	Date

Project No: 72

Drawn By: CLM Checked By: CLM


Sheet Title:

BUILDING SECTIONS


Sheet Number:

A-301


Original Drawing: 100% = 34" x 22" - DO NOT SCALE WHEN REPRODUCED AT ANY OTHER SIZE

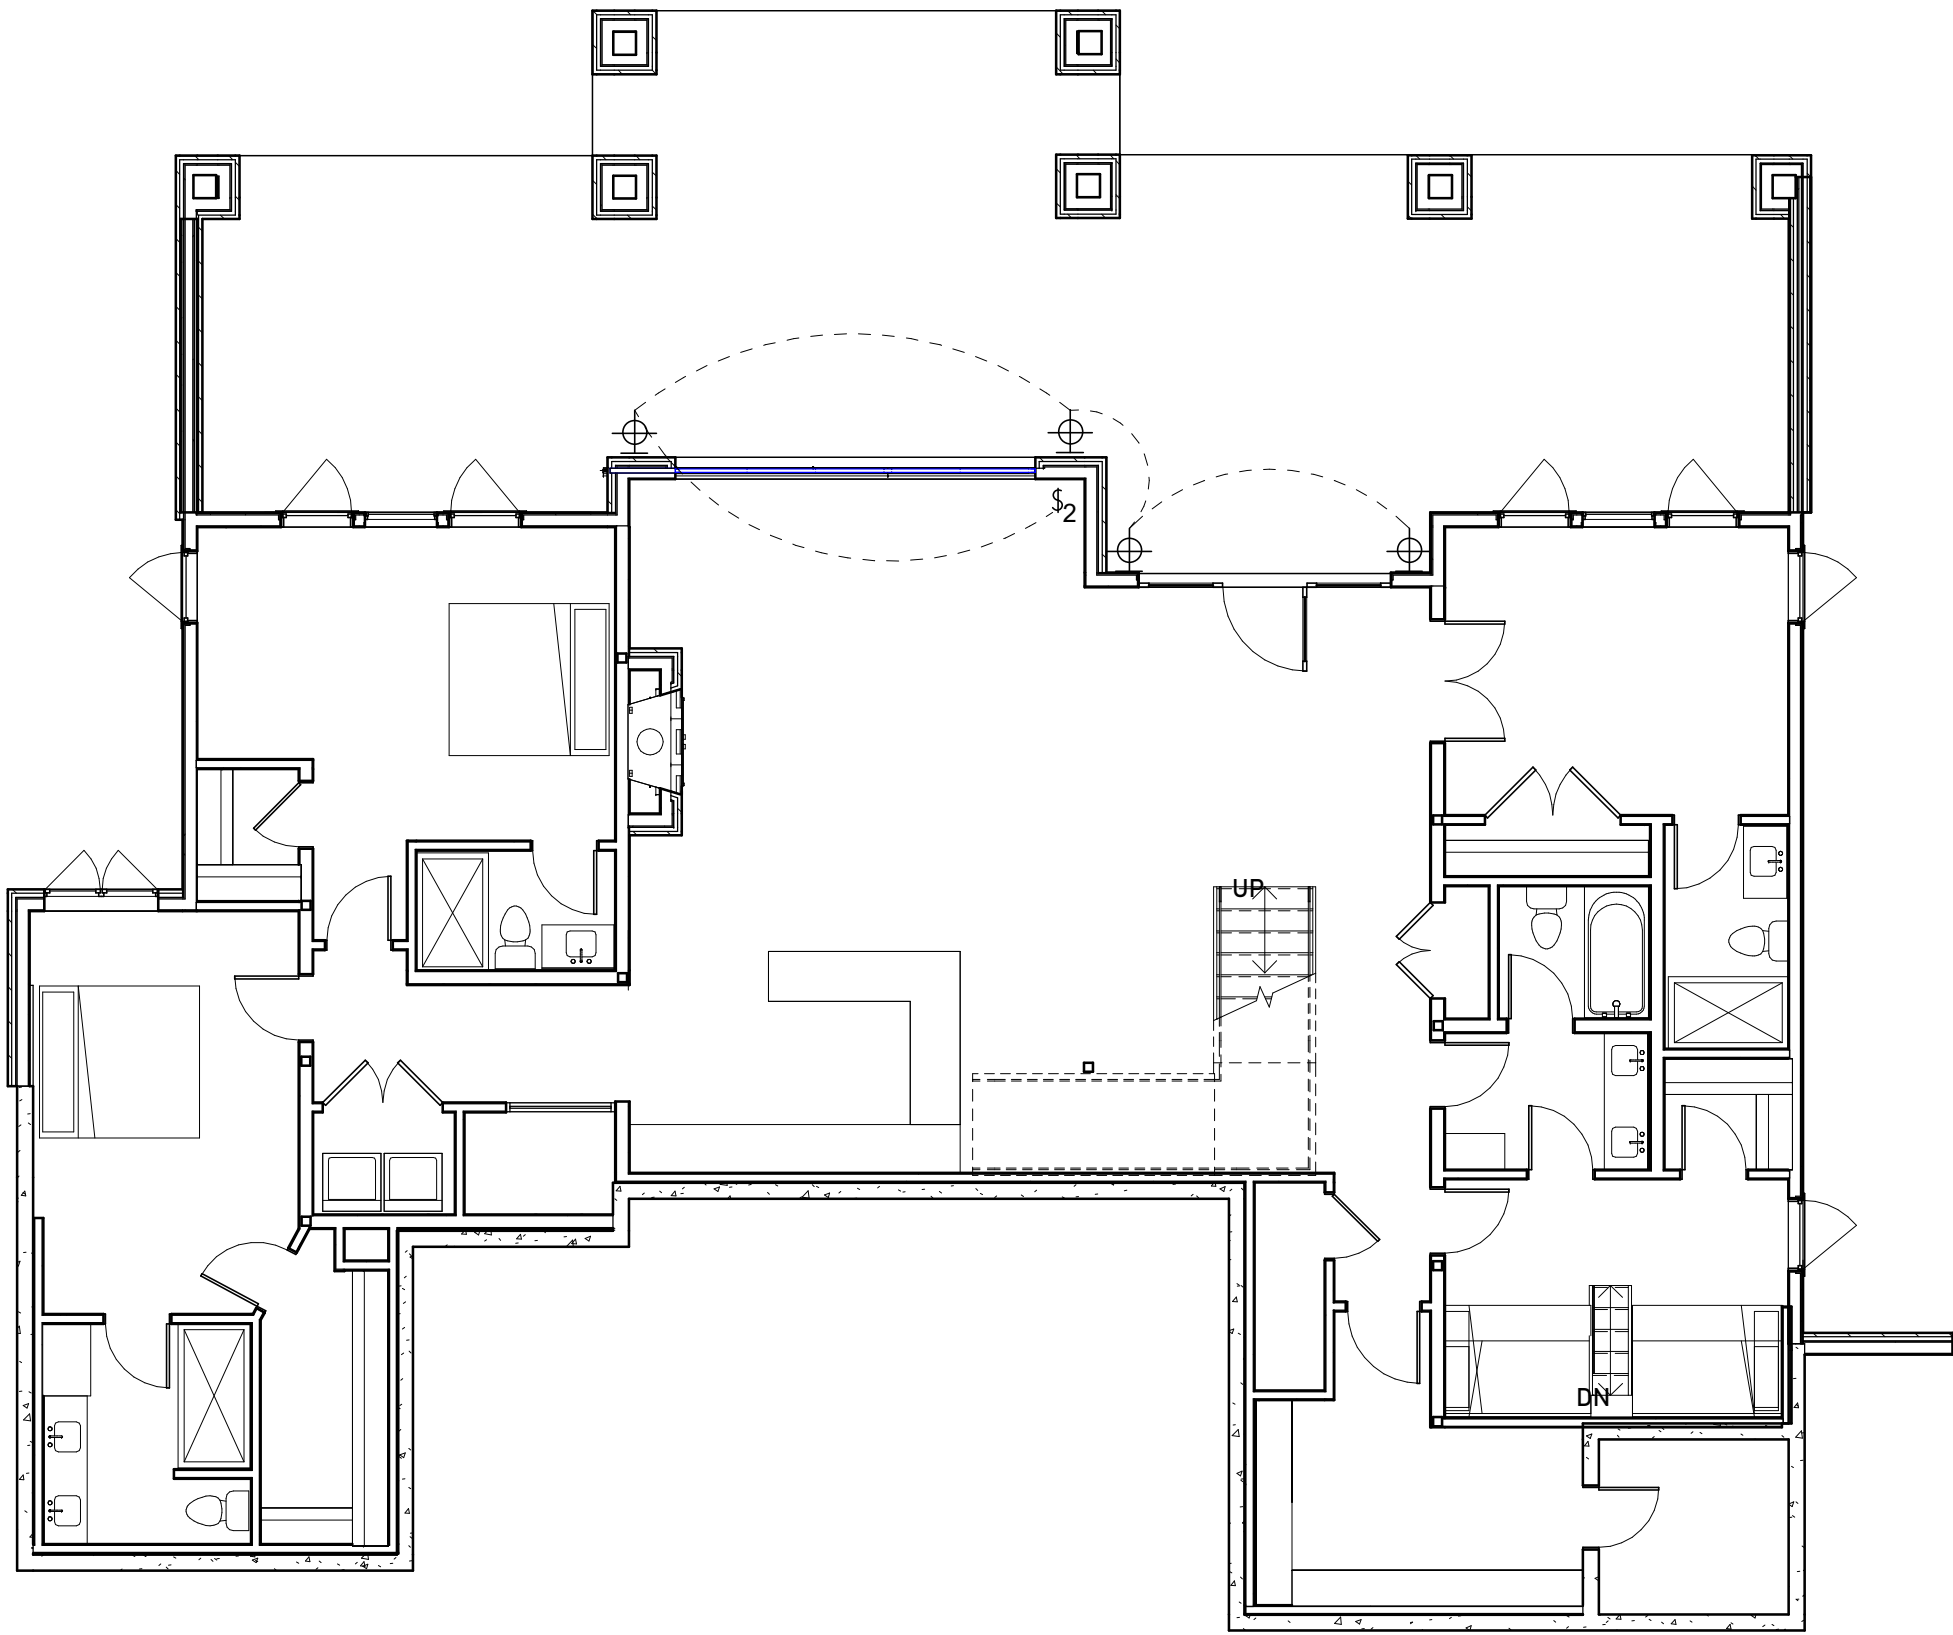

A1 Lower Level - Floor Plan Electrical
Scale: 1/8" = 1'-0"

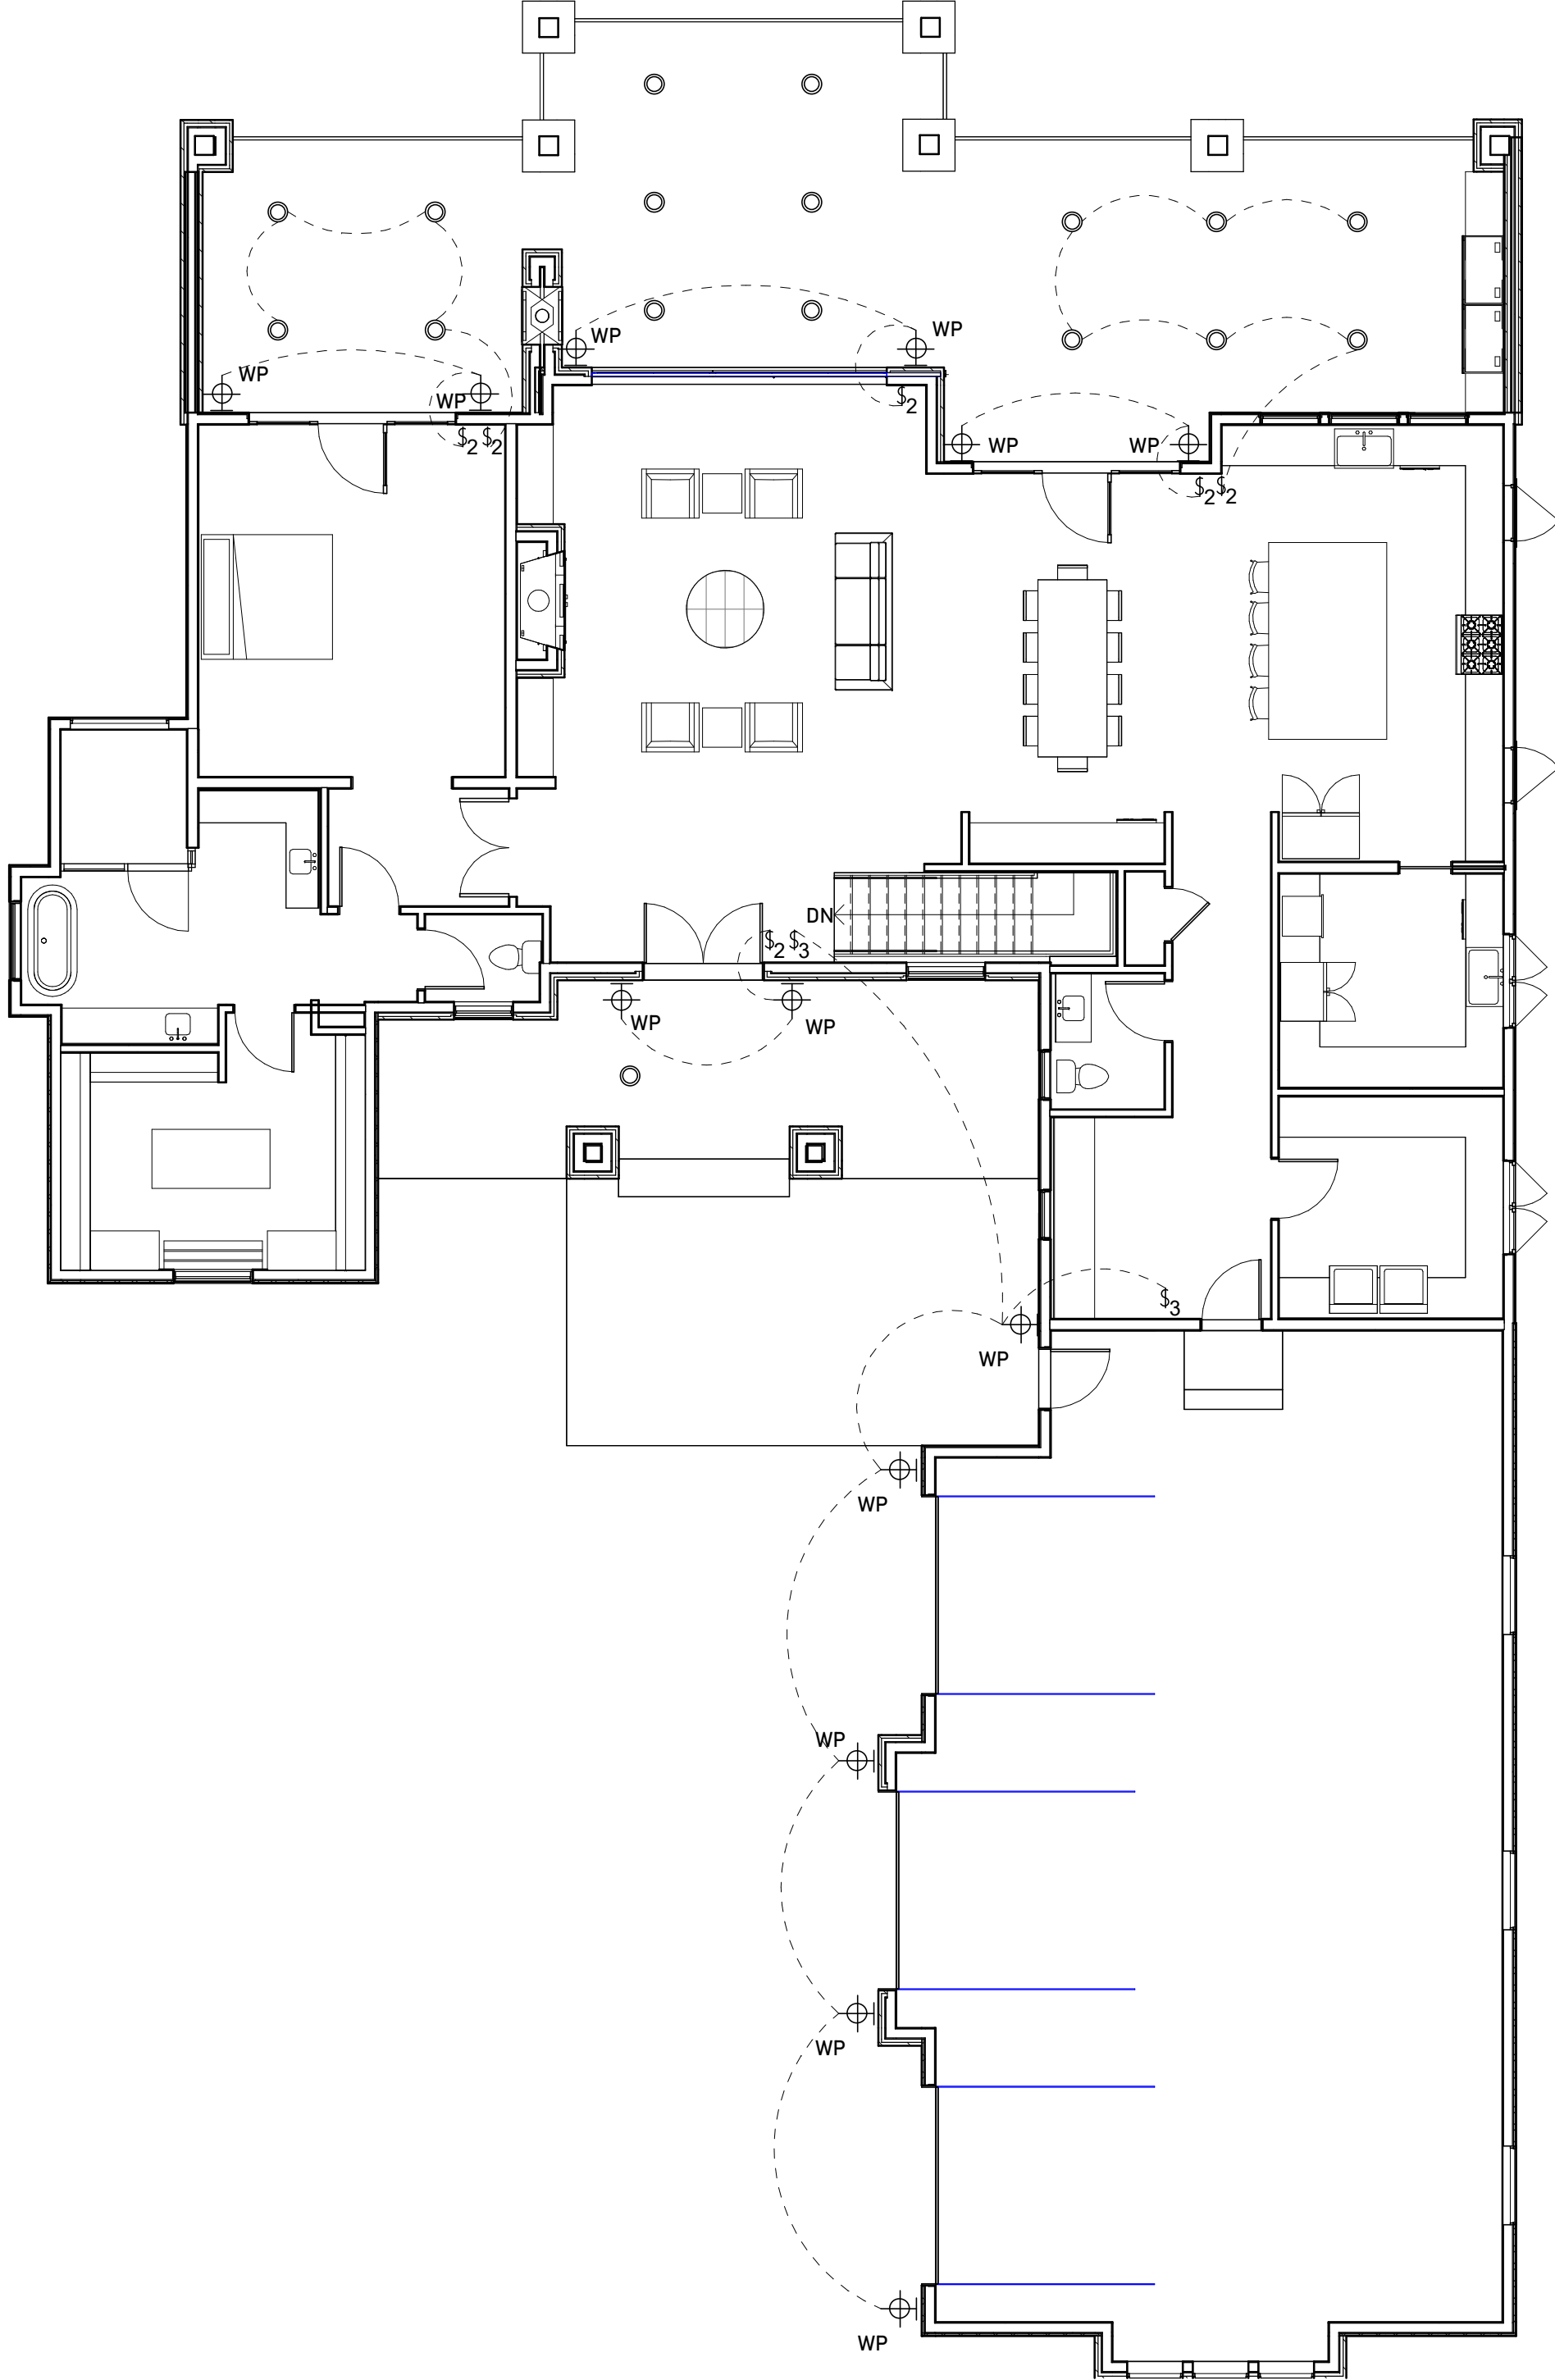

 A3 First Level - Electrical Floor Plan
Scale: 1/8" = 1'-0"



PO BOX 313 | Sheridan, Wyoming 82801 | 307.299.1001
All reproduction & intellectual property rights reserved © 2026 Studio CMS LLC

Project Status:
Powder Horn Final Design
Review Submittal

Geuke Residence

POWDER HORN RANCH PUD PHASE THREE BLOCK M LOT 3 SHERIDAN WY
82801

Prepared for:
Sonya and Brad Geuke

Revisions:		
No.	Description	Date


Project No: 72
Drawn By: CLM Checked By: CLM

Sheet Title:
**FIRST LEVEL EXTERIOR
LIGHTING FLOOR PLAN**


Sheet Number:

A-701


Original Drawing: 100% = 34" x 22" - DO NOT SCALE WHEN REPRODUCED AT ANY OTHER SIZE

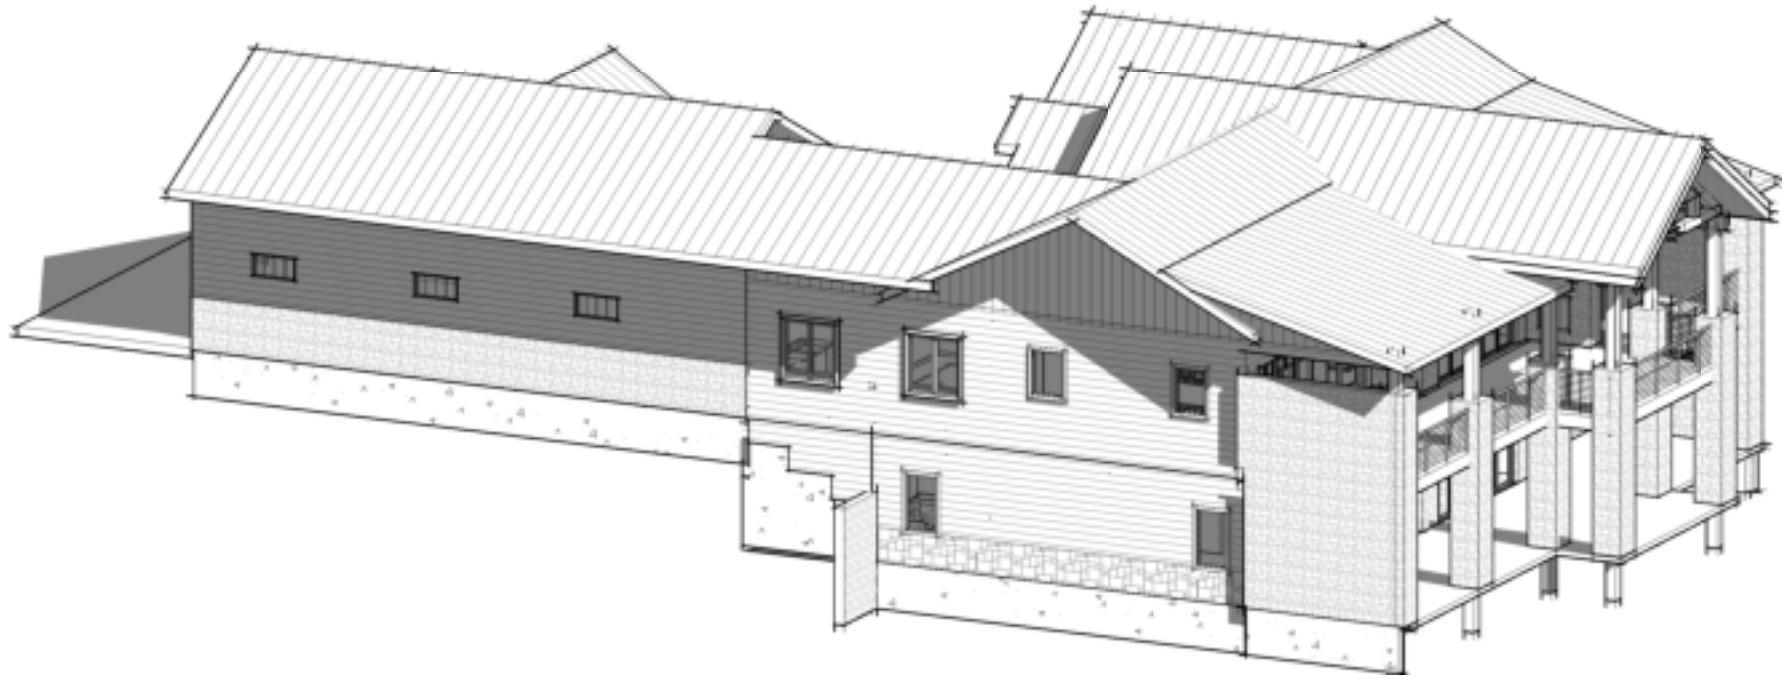

C1 Axon - Southwest
Scale:

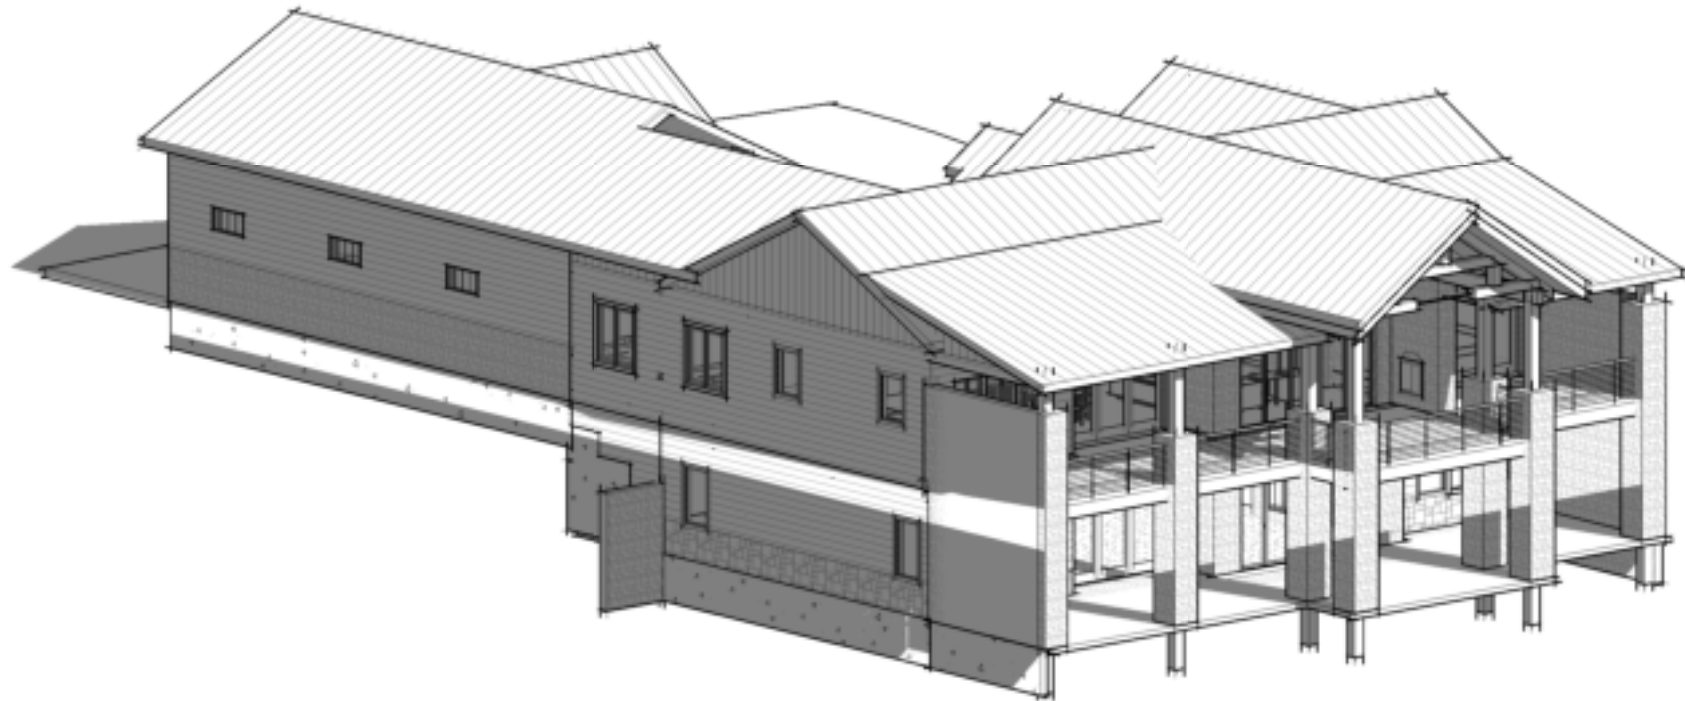


B1 Front View 1
Scale:

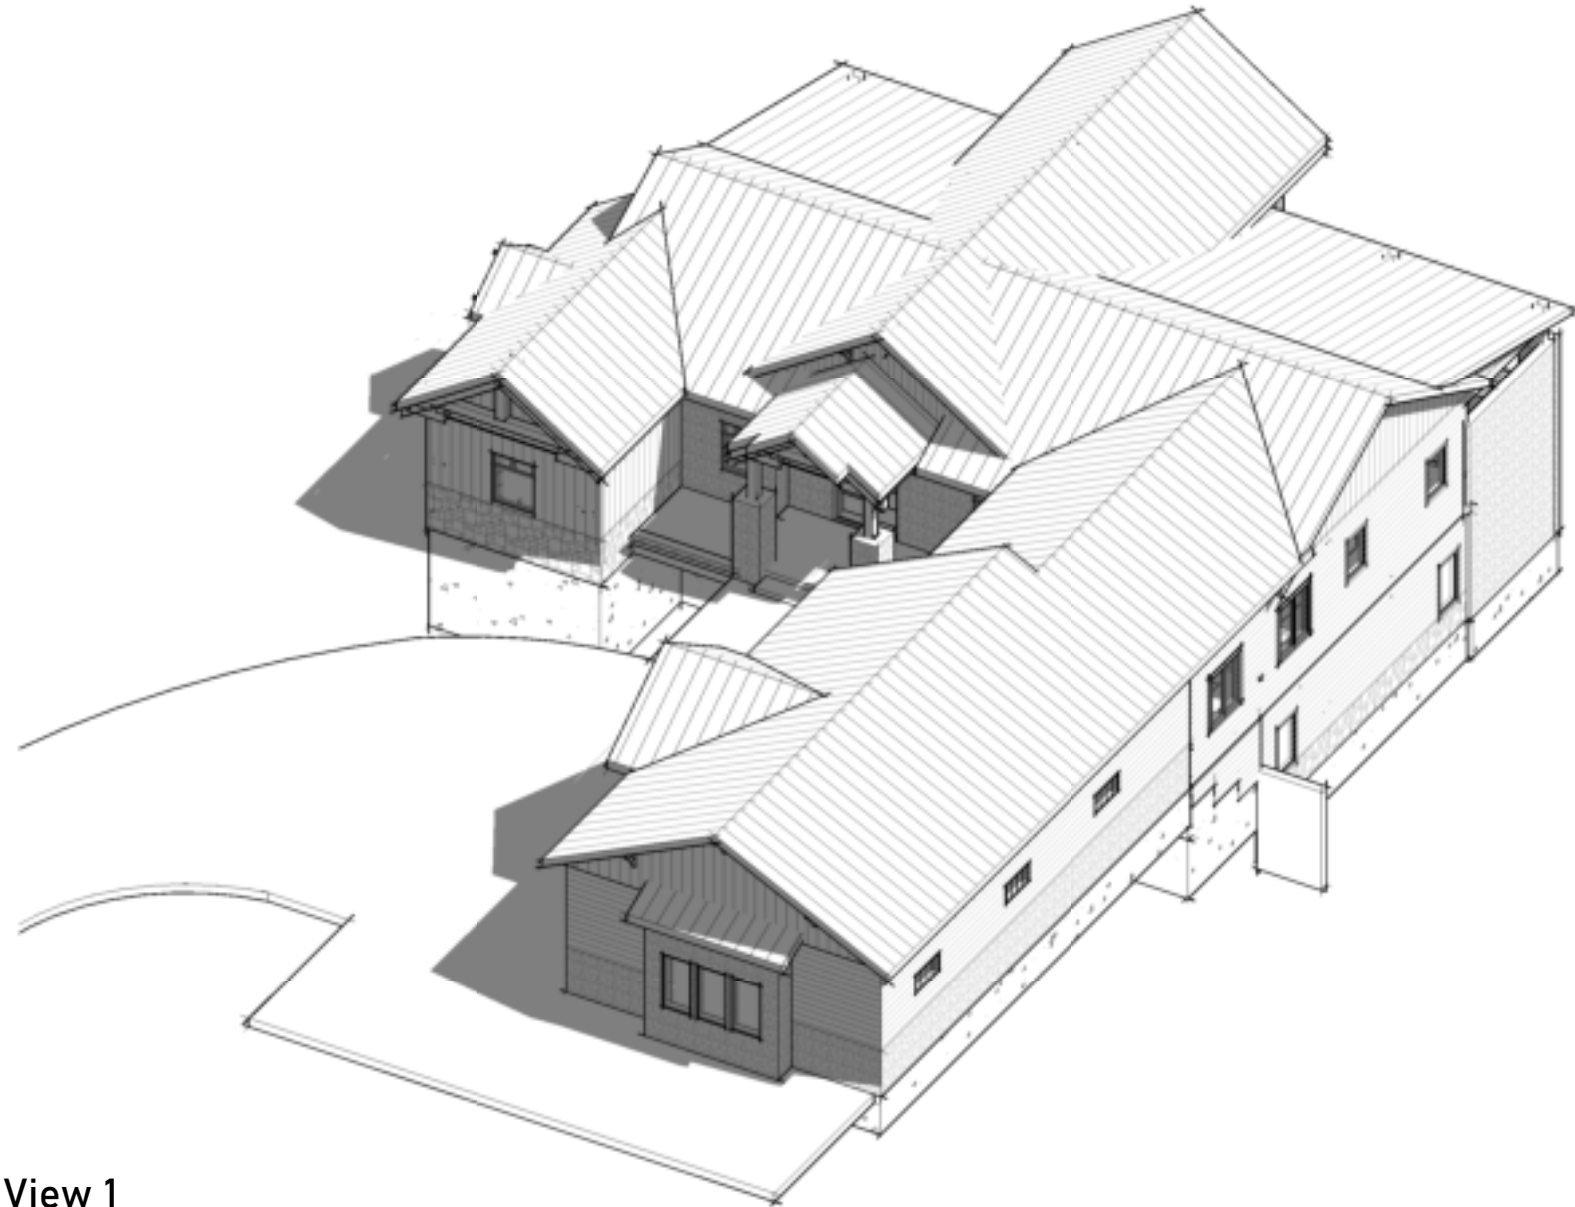


A1 Aerial View 1
Scale:



C3 Back View 2
Scale:

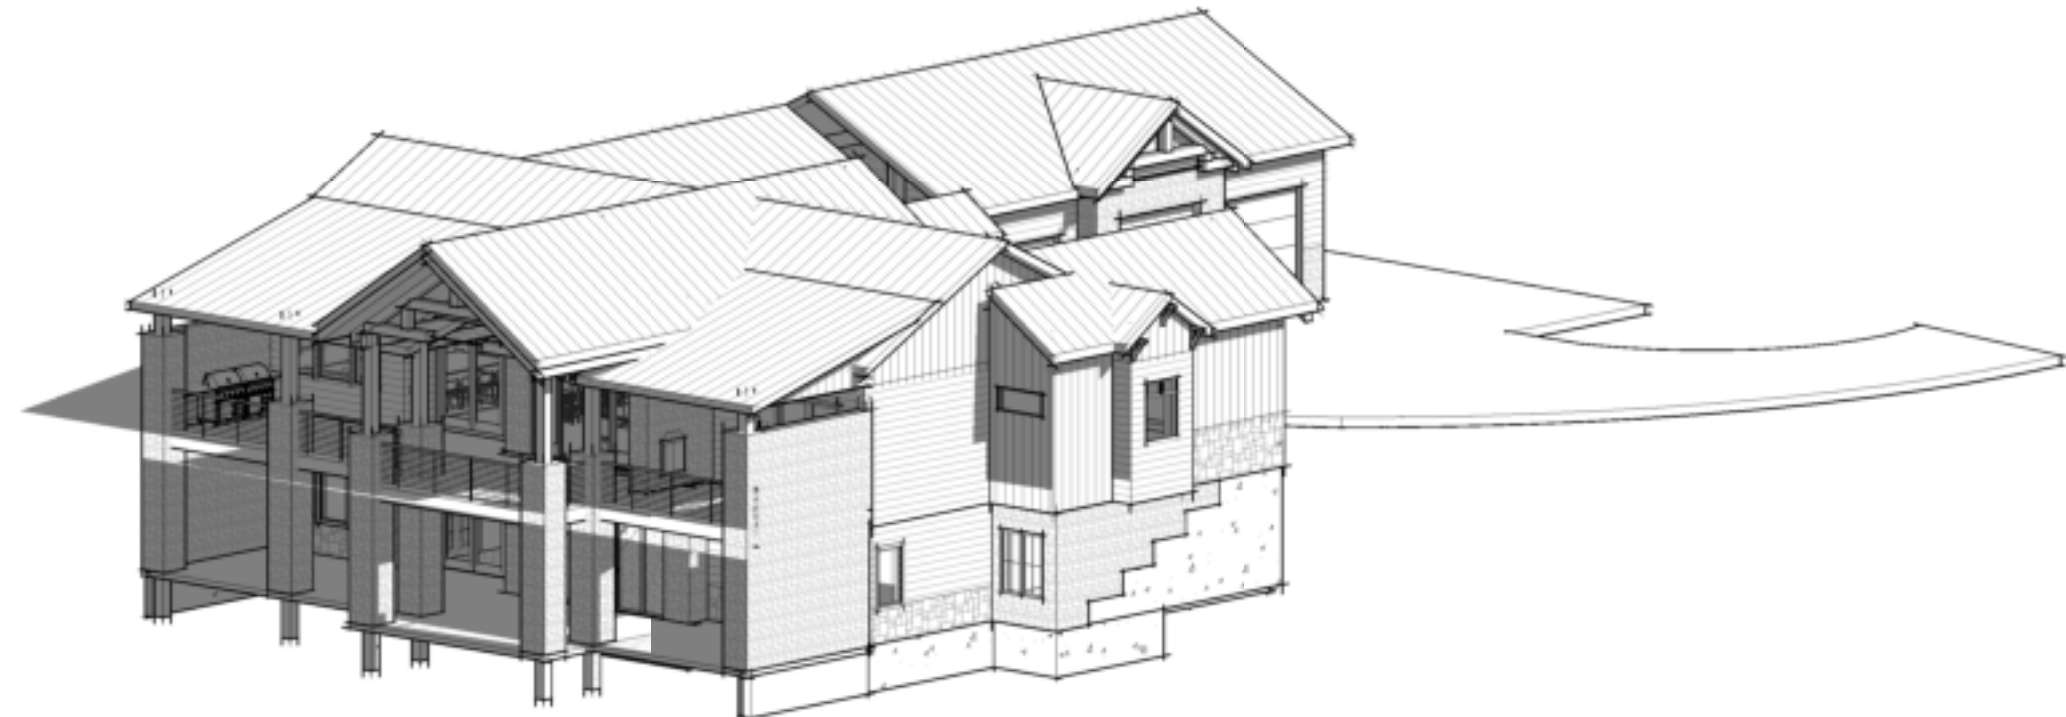

A3 Front View 2
Scale:

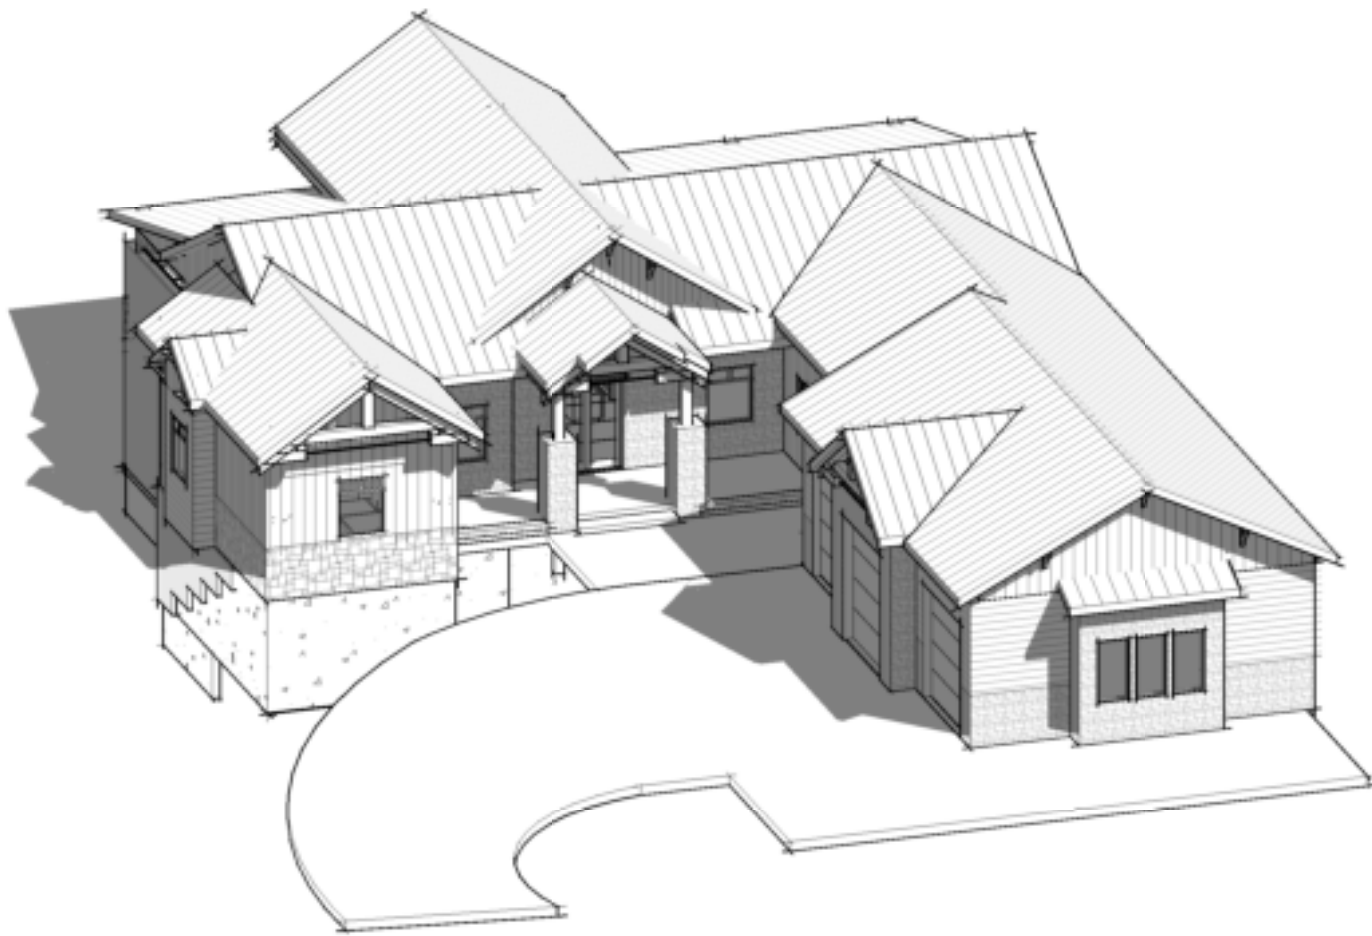

B3 Axon - Northeast
Scale:



Studio CMS

PO BOX 313 | Sheridan, Wyoming 82801 | 307.299.1001
All reproduction & intellectual property rights reserved © 2026 Studio CMS LLC

Project Status:

**Powder Horn Final Design
Review Submittal**

Geuke Residence

POWDER HORN RANCH PUD PHASE THREE BLOCK M LOT 3 SHERIDAN WY

82801

Prepared for:

Sonya and Brad Geuke

Revisions:

No.	Description	Date

Project No: 72

Drawn By: CM Checked By: CLM

Sheet Title:

3D VIEWS

Sheet Number:

A-901